
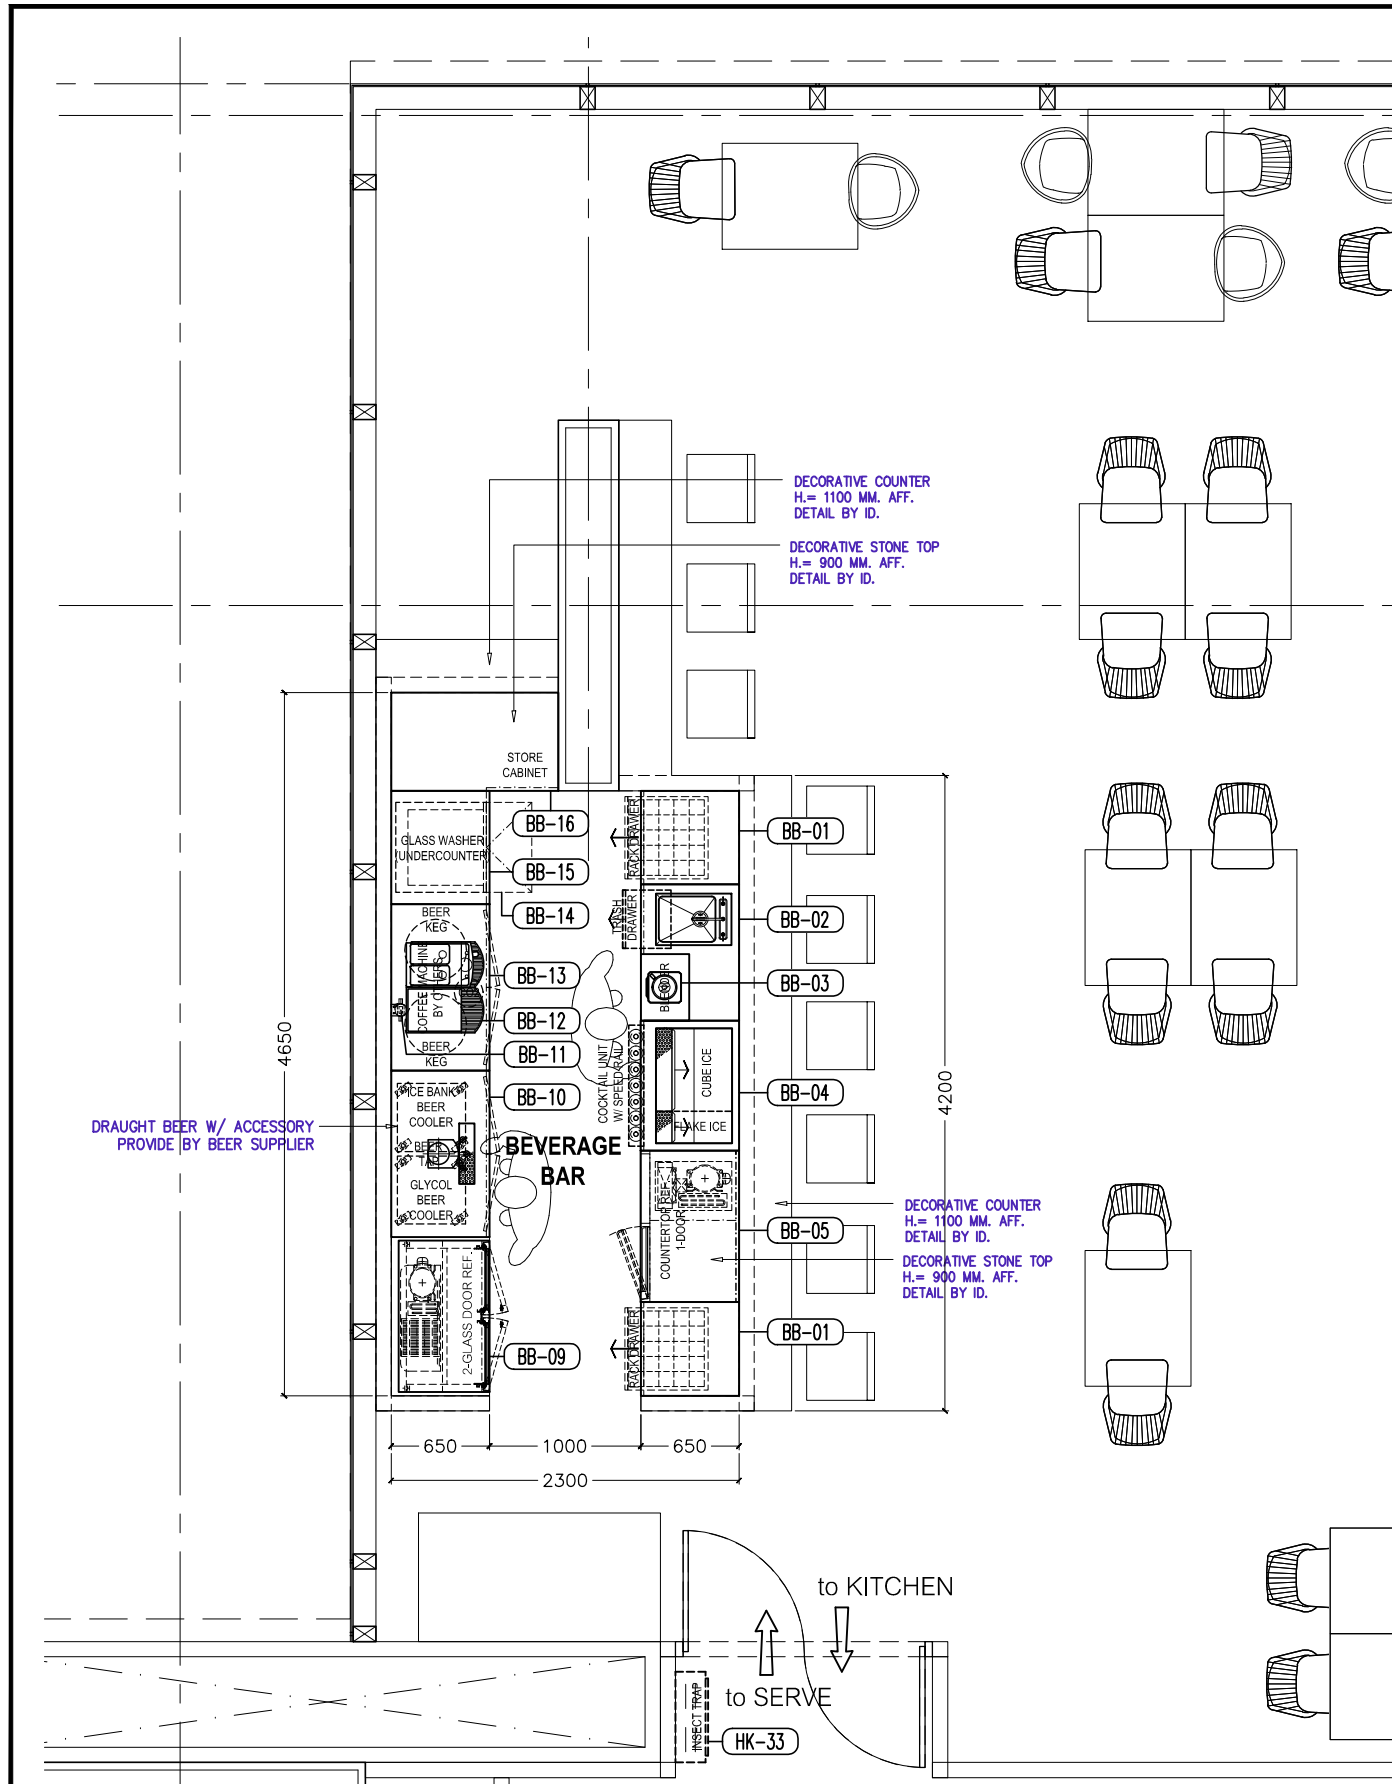


UPDATE DRAWING : 160519


 <p>Thanakorn Holding Co., Ltd. 458/24-25 Mooban Kulaparak M.1 Rattana Raj Road, T. Bangor A. Bangor Samutprakarn 10560, Thailand Tel : +662-3381465, Fax : +662-3381849 E-Mail : gm@thanakornholding.com</p>	PROJECT NAME:	REV	DATE	CHK	DESCRIPTION	DRAWING TITLE:	DRAWING DETAIL
	Ibis Styles Hotel @ Prakanong					MAIN KITCHEN	
						7th. FLOOR PLAN	
						EQUIPMENT LAYOUT	
						LOCATION:	IBS-TL-404-410-10019.DWG
						SHEET CONTENTS:	SCALE: 1:125
							DESIGNER: K
							CHECKED:
							APPROVED:
							DATE: 150105
							PROJECT: IBS-1501
							SHEET NO:
							DRG. NO:
							KQ-03



Room Ref.No.	Equipment Description	Tender Specified		Qty
		Make	Model	
7FL. MAIN KITCHEN & ALL DAY DINING RESTAURANT				
BEVERAGE BAR				
BB 01	RACK SLIDES CABINET	CUSTOM MADE	620x650x880	2 Ea
BB 02	BLENDER STATION	CUSTOM MADE	900x650x880	1 Ea
BB 03	BLENDER, ON-COUNTER	VITAMIX	42009	1 Ea
BB 04	COCKTAIL UNIT W/ SPEED RAIL	CUSTOM MADE	860x650x880	1 Ea
BB 05	UNDERCOUNTER REFRIGERATOR, 1-SOLID DOOR	CUSTOM MADE	1000x650x880	1 Ea
BB 06	SPARE ITEM			
BB 07	SPARE ITEM			
BB 08	SPARE ITEM			
BB 09	BOTTLE COOLER, 2-GLASS DOOR	CUSTOM MADE	1000x650x880	1 Ea
BB 10	HINGE DOOR CABINET W/ DRAIN TROUGH	CUSTOM MADE	1100x650x880	1 Ea
BB 11	WATER FILTER	BY PURVEYOR	N/A	1 Ea
BB 12	COFFEE MACHINE	BY PURVEYOR	N/A	1 Ea
BB 13	HINGE DOOR CABINET W/O UNDER SHELF	CUSTOM MADE	1100x650x880	1 Ea
BB 14	UNDERCOUNTER GLASS WASHER	ELECTROLUX	400141	1 Ea
BB 15	OPEN CABINET W/O UNDER SHELF	CUSTOM MADE	750x650x880	1 Ea
BB 16	OPEN CABINET W/ UNDER SHELF	CUSTOM MADE	1100x650x880	1 Ea
BB 17	SPARE ITEM			
BB 18	SPARE ITEM			


UPDATE DRAWING : 160519

<p>Thanakorn Holding Co., Ltd. 458/24-25 Mooban Kulapapruk M.1 Rattana Raj Road, T. Bangbor A. Bangbor Samutprakarn 10560, Thailand Tel : +662-3381465, Fax : +662-3381849 E-Mail : gm@thanakornholding.com</p>	PROJECT NAME:	REV	DATE	CHK	DESCRIPTION	DRAWING TITLE:	DRAWING DETAIL					
	Ibis Styles Hotel @ Prakanong					MAIN KITCHEN	CAD FILE	BS-7FL-4M-4IG-103-10019.DWG	DATE:	150105		
						7th. FLOOR PLAN	SCALE	1:50	DRAWN	K	CHECKED	APPROVED
						EQUIPMENT LAYOUT	PRODUCT	IBS-1501	SHEET NO.	DRG. NO.		KQ-04

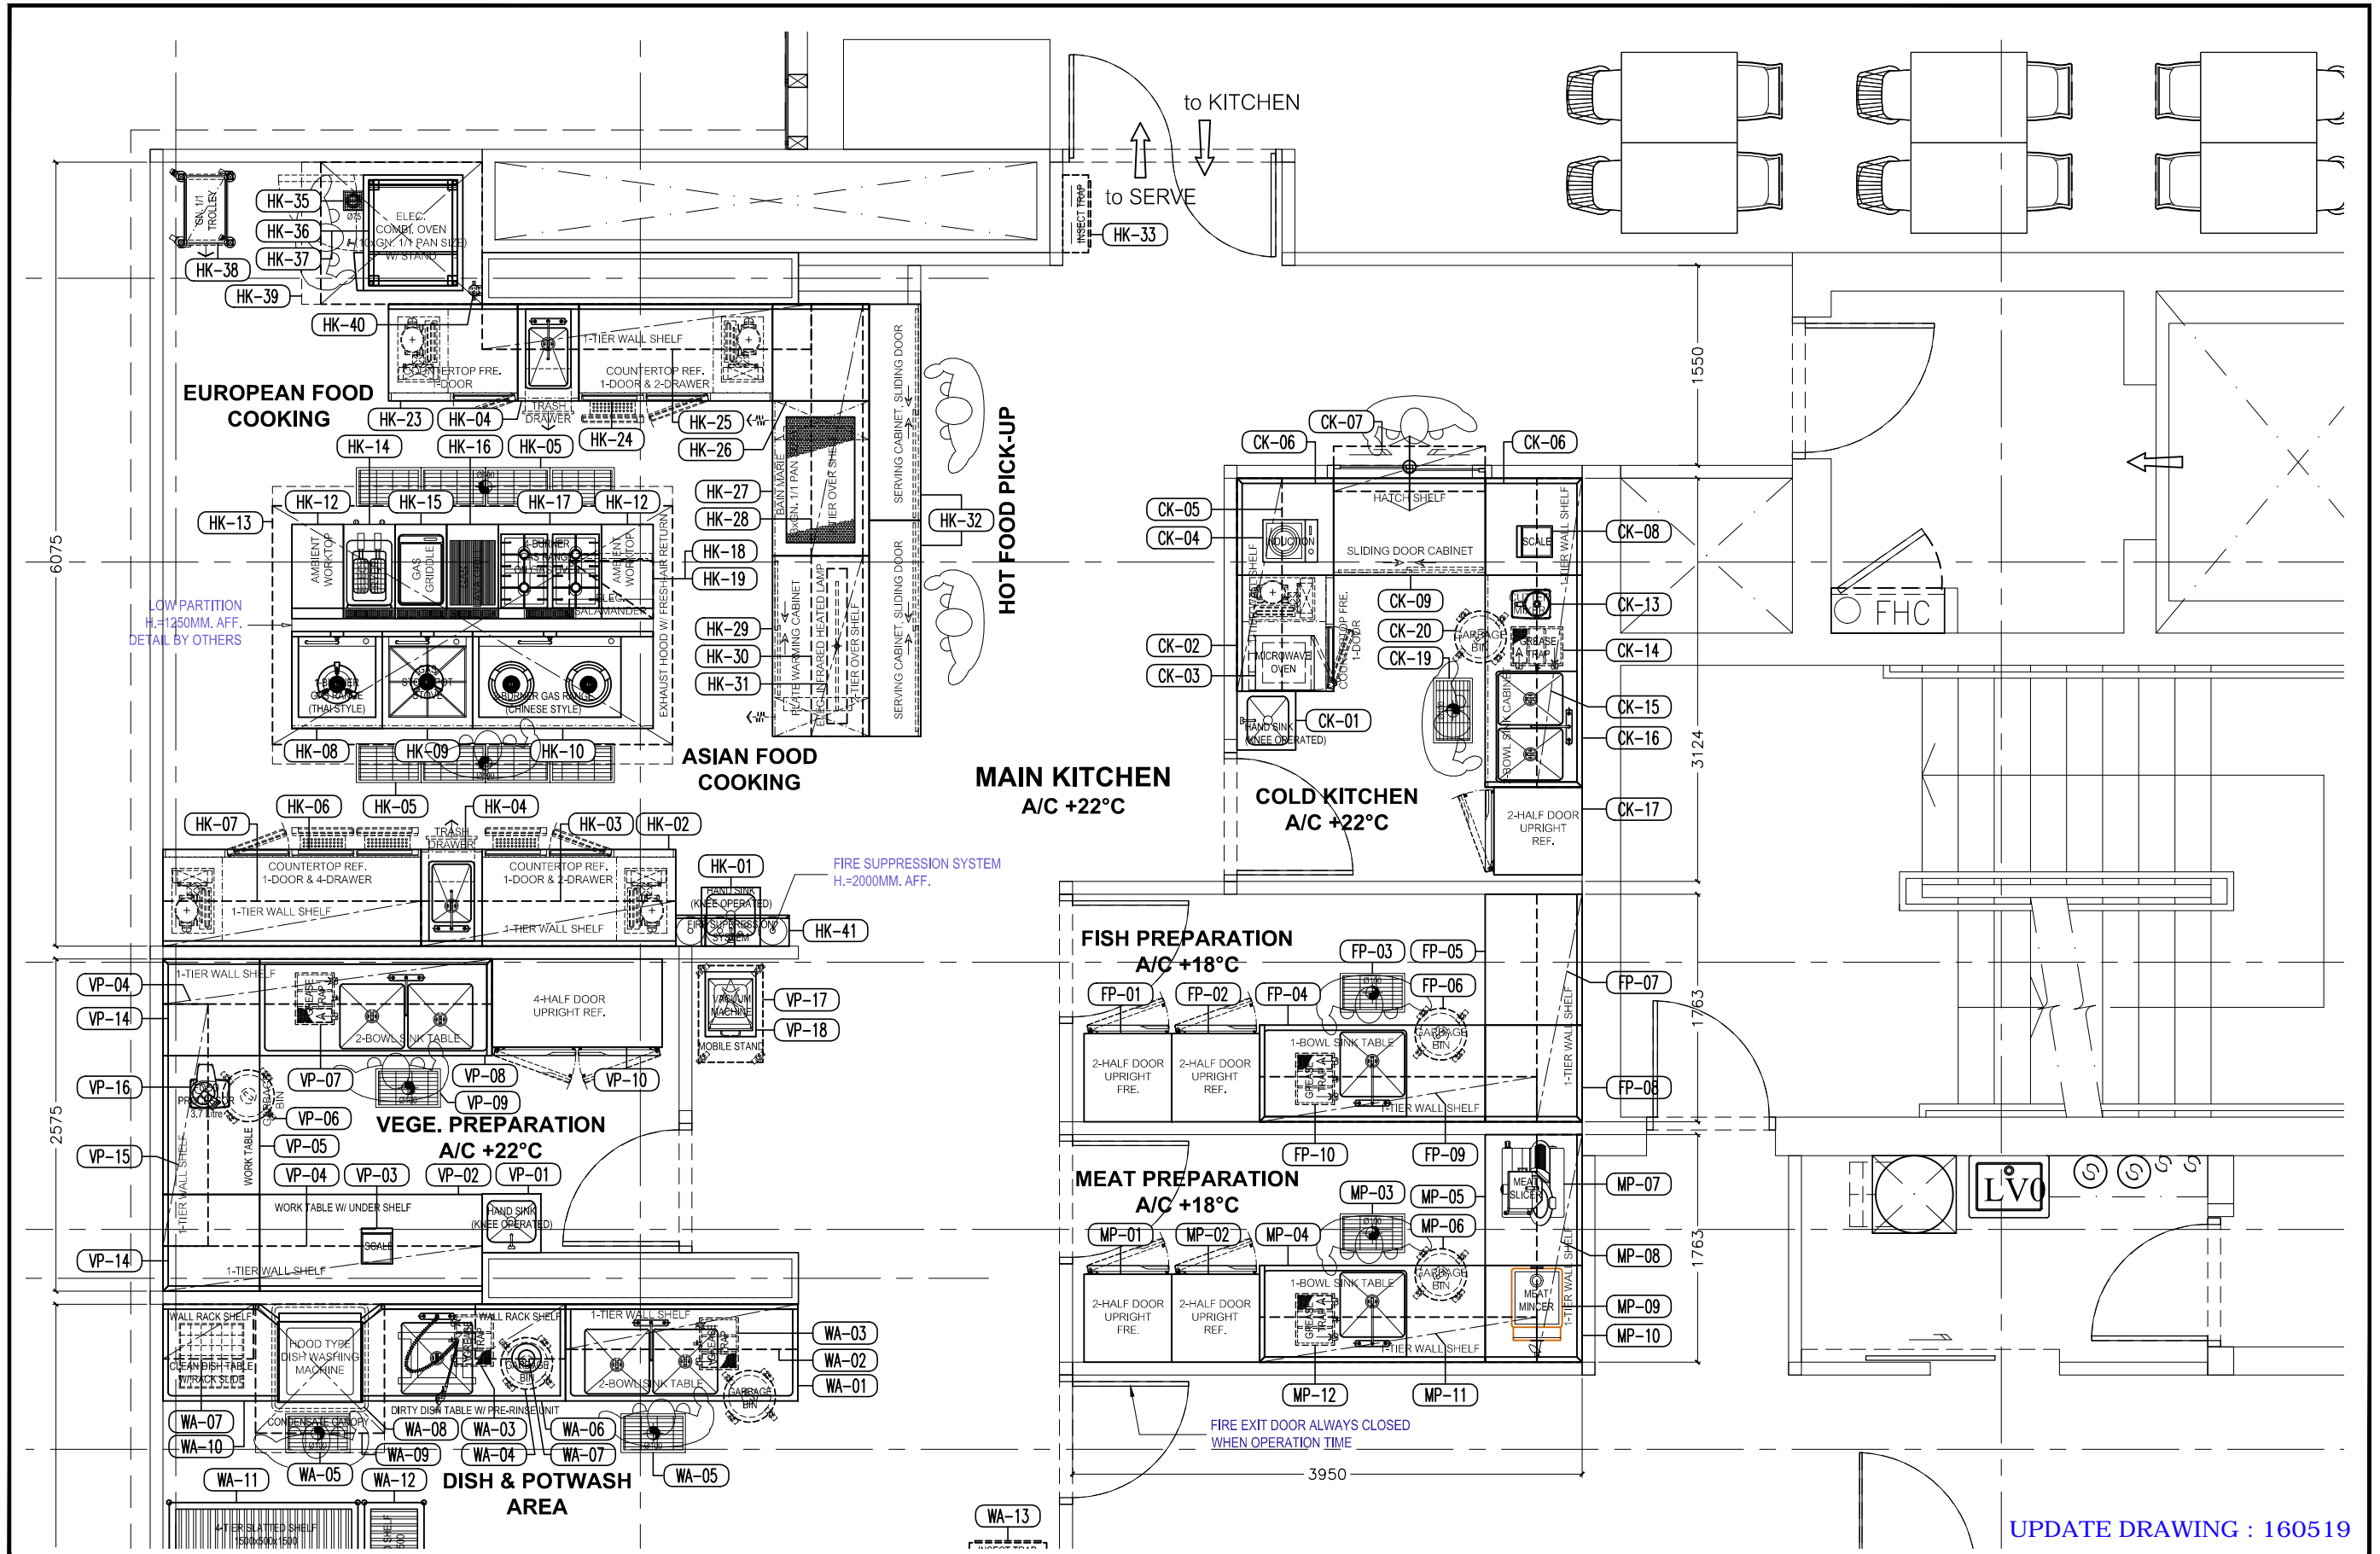

UPDATE DRAWING : 160519

<p>Thanakorn Holding Co., Ltd. 458/24-25 Mooban Kulapaprak M.1 Rattana Raj Road, T. Bangbor A. Bangbor Samutprakarn 10560, Thailand Tel : +662-3381465, Fax : +662-3381849 E-Mail : gm@thanakornholding.com</p>	PROJECT NAME:	Ibis Styles Hotel @ Prakanong	REV	DATE	CHK	DESCRIPTION	DRAWING TITLE:	MAIN KITCHEN	DRAWING DETAIL						
							LOCATION:	7th. FLOOR PLAN	CAD FILE	BS-7FL-4M-4IG-H03-10019.DWG	DATE:	150105			
							SHEET CONTENTS:	EQUIPMENT LAYOUT	SCALE	1:50	DRAWN	K	CHECKED	APPROVED	
									PRODUCT	IBS-1501	SHEET NO.		DRG. NO.		KQ-05

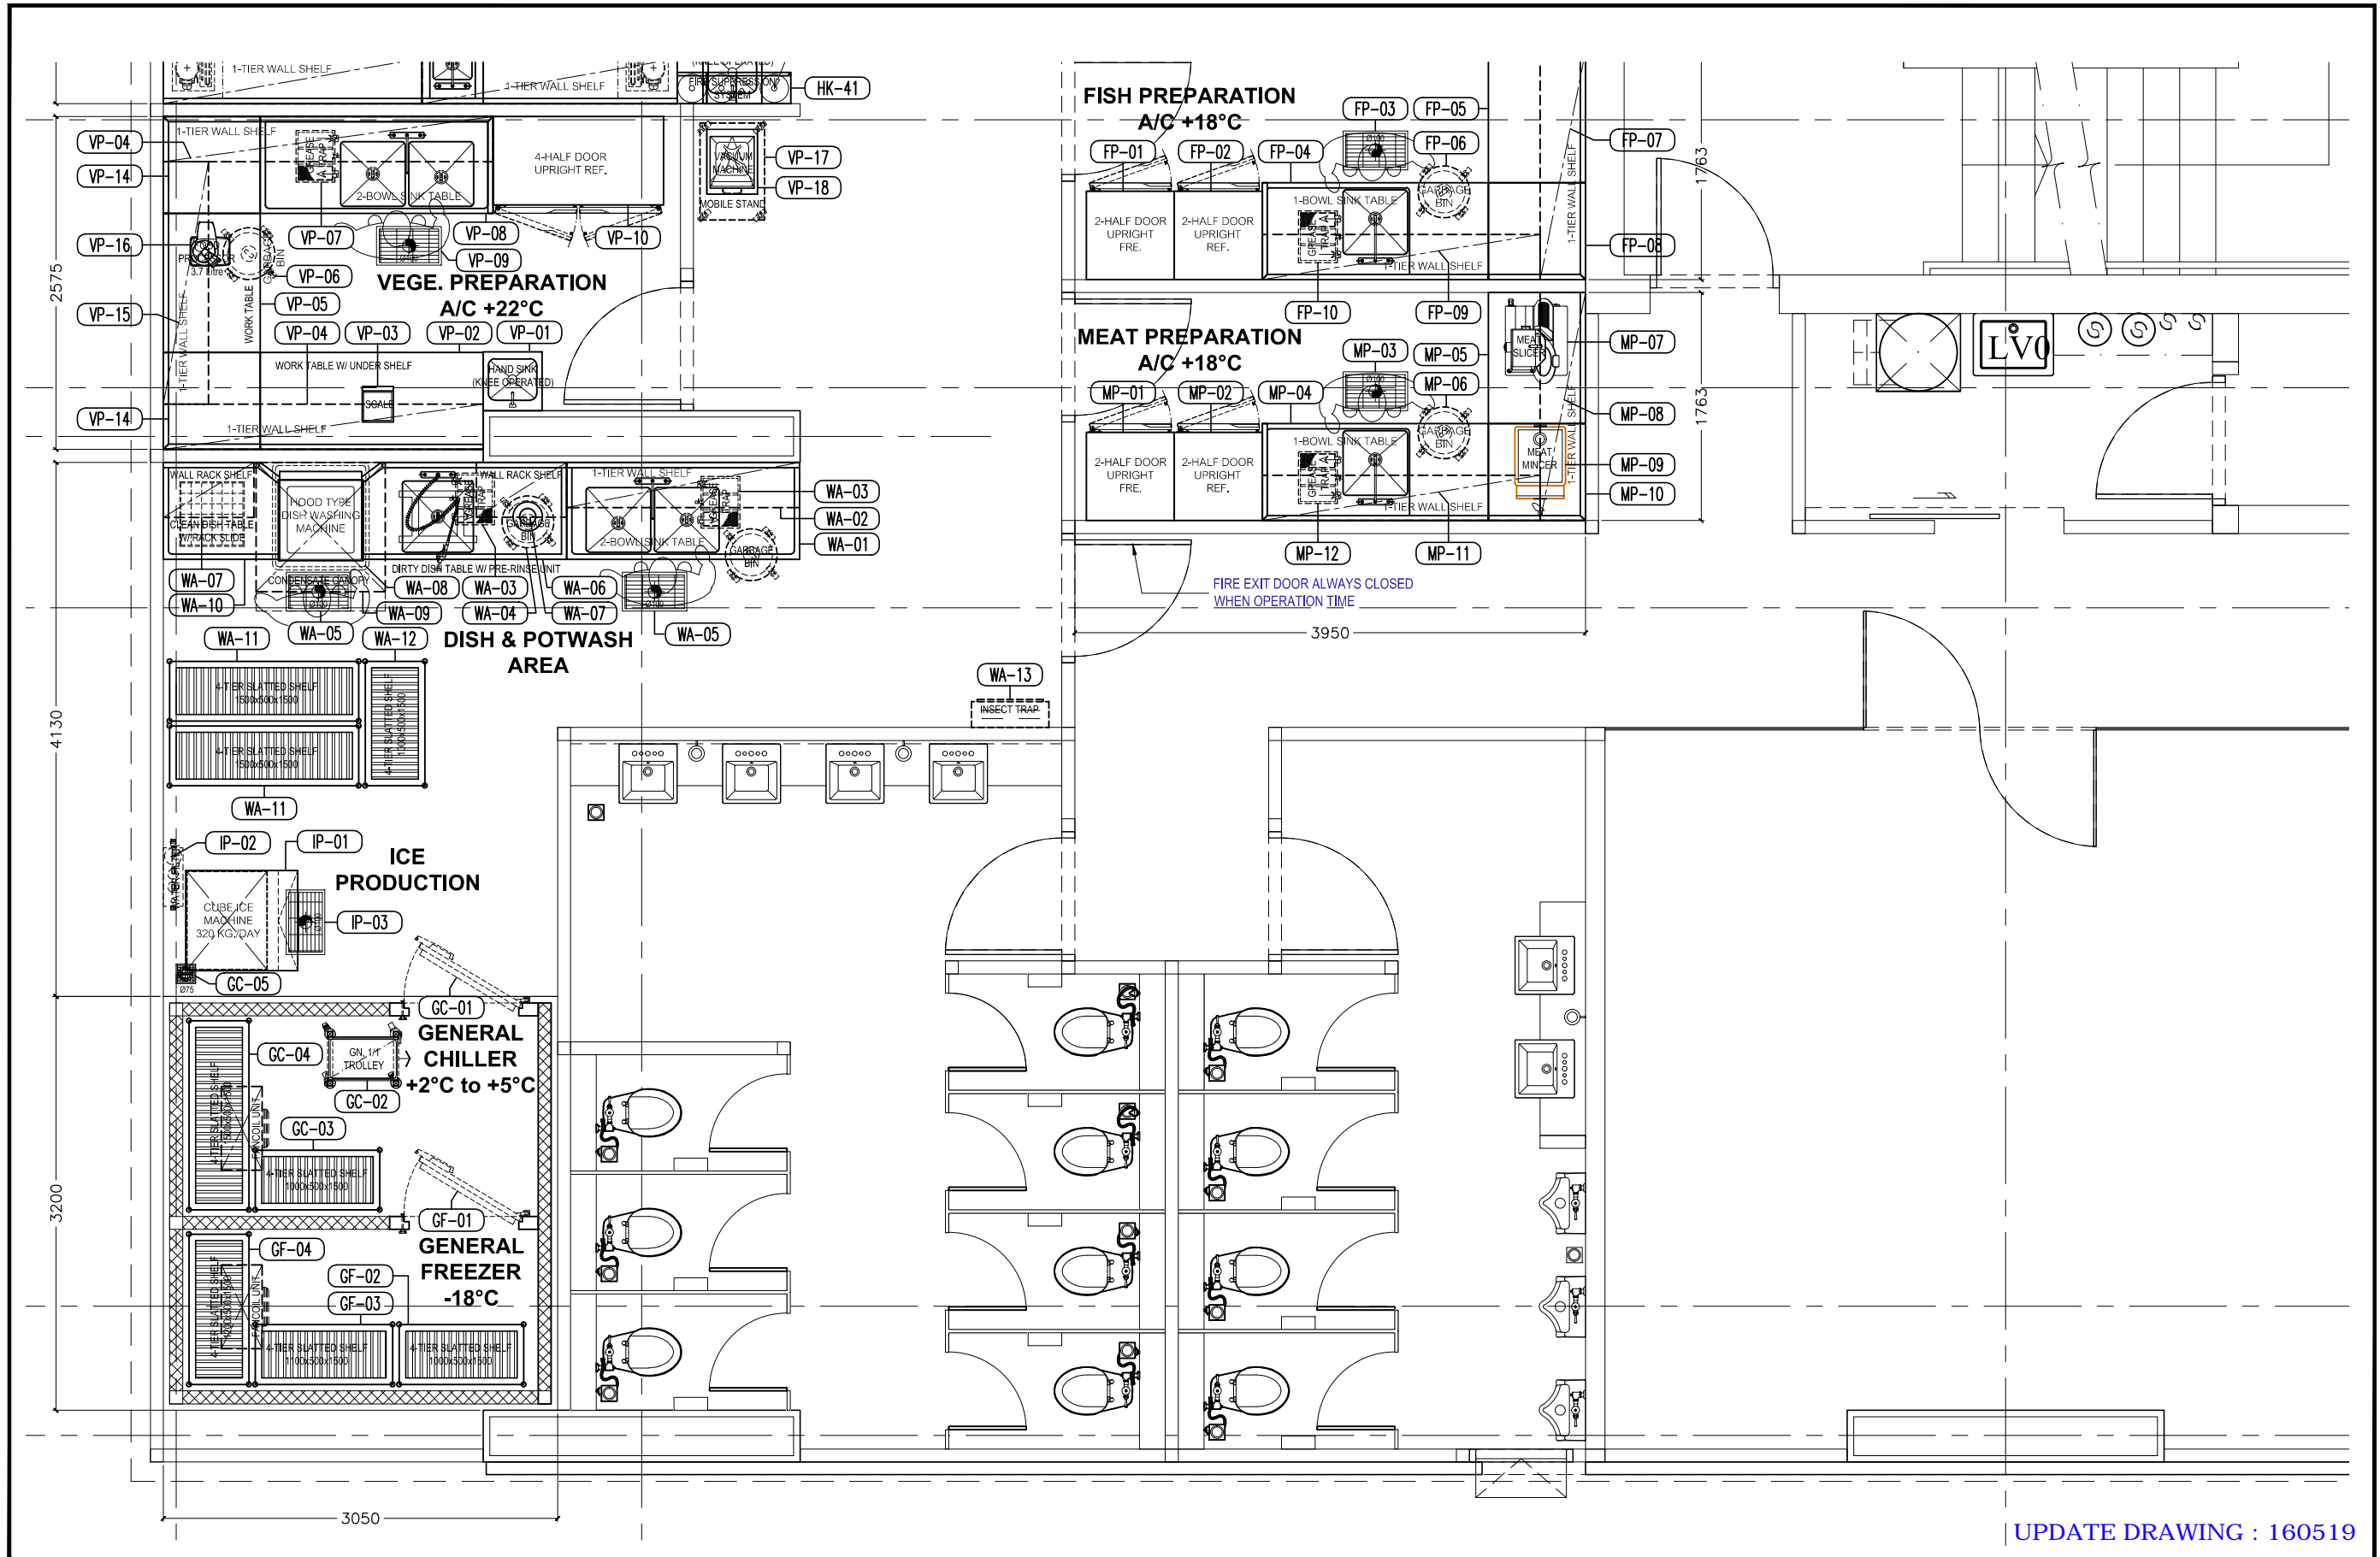

UPDATE DRAWING : 160519


<p>Thanakorn Holding Co., Ltd. 458/24-25 Mooban Kulapapruk M.1 Rattianaraj Road, T. Bangbor A. Bangbor Samutprakarn 10560, Thailand Tel : +662-3381465, Fax : +662-3381849 E-Mail : gm@thanakornholding.com</p>	PROJECT NAME:	Ibis Styles Hotel @ Prakanong			REV	DATE	CHK	DESCRIPTION	DRAWING TITLE:	MAIN KITCHEN	DRAWING DETAIL							
									LOCATION:	7th. FLOOR PLAN	CAD FILE	BS-7FL-404-410-10019.DWG	DATE:	150105				
									SHEET CONTENTS:	EQUIPMENT LAYOUT	SCALE:	1:50	DRAWN:	K	CHECKED:		APPROVED:	
											PRODUCT:	IBS-1501	SHEET NO.:		DRG. NO.:			


COLD KIT CHEN				
CK 01	HAND WASH SINK CABINET, KNEE OPERATED	LEECO	ST-4545	1 Ea
CK 02	COUNTER TOP FREEZER, 1-SOLID DOOR	CUS TOM MADE	1000x750x850+150	1 Ea
CK 03	MICROWAVE OVEN	PANASONIC	NE-1756	1 Ea
CK 04	INDUCTION UNIT	PRC BE	TT-2500	1 Ea
CK 05	WALL SHELF, 1-TIER	CUS TOM MADE	1650x350	1 Ea
CK 06	CORNER FILLER TOP	CUS TOM MADE	750x750x850+150	2 Ea
CK 07	HATCH SHELF	CUS TOM MADE	1175x350	1 Ea
CK 08	PORTABLE SCALE, MAX. 6KG., E=1G	DGI	DS-673	1 Ea
CK 09	SLIDING DOOR CABINET	CUS TOM MADE	1075x750x850+150	1 Ea
CK 10	SPARE ITEM			
CK 11	SPARE ITEM			
CK 12	SPARE ITEM			
CK 13	CUTTER-MIXER	ROBOT COUPE	R5VV	1 Ea
CK 14	GREASE TRAP	CUS TOM MADE	300x400x400	1 Ea
CK 15	WALL SHELF, 1-TIER	CUS TOM MADE	2395x350	1 Ea
CK 16	SINK CABINET, 2-BOWL	CUS TOM MADE	1645x750x850+150	1 Ea
CK 17	UPRIGHT REFRIGERATOR, 2-SOLID HALF DOOR	CUS TOM MADE	680x750x2050	1 Ea
CK 18	SPARE ITEM			
CK 19	FLOOR GULLY W/ GRATING	CUS TOM MADE	300x500x150+100	1 Ea
CK 20	MOBILE GARBAGE BIN	CUS TOM MADE	Ø435x550+110	1 Ea
CK 21	SPARE ITEM			
CK 22	SPARE ITEM			
HOT KIT CHEN				
HK 01	HAND WASH SINK CABINET, KNEE OPERATED	LEECO	ST-4545	1 Ea
HK 02	COUNTER TOP REFRIGERATOR, 1-DOOR & 2-DRAWER	CUS TOM MADE	1500x750x850+150	1 Ea
HK 03	WALL SHELF, 1-TIER	CUS TOM MADE	1975x350	1 Ea
HK 04	SINK CABINET W/ TRASHDRAWER	CUS TOM MADE	475x750x850+150	2 Ea
HK 05	FLOOR GULLY W/ GRATING	CUS TOM MADE	2000x300x150+100	2 Ea
HK 06	COUNTER TOP REFRIGERATOR, 1-DOOR & 4-DRAWER	CUS TOM MADE	2000x750x850+150	1 Ea
HK 07	WALL SHELF, 1-TIER	CUS TOM MADE	2000x350	1 Ea
HK 08	1-GAS WOK RANGE, THAI STYLE	CUS TOM MADE	700x750x2050	1 Ea
HK 09	1-GAS STOCK POTSDOVE	CUS TOM MADE	700x750x2050	1 Ea
HK 10	2-GAS WOK RANGE, CHINESE STYLE	CUS TOM MADE	1400x750x2050	1 Ea
HK 11	SPARE ITEM			
HK 12	AMBIENT WORK TOP ON CUPBOARD	ELECTROLUX	371117+371112	2 Ea
HK 13	EXHAUST HOOD W/ FRESH-AIR RETURN	CUS TOM MADE	3100x2150x500	1 Ea
HK 14	ELEC. DEEP FAT FRYER	ELECTROLUX	371140+371112	1 Ea
HK 15	GAS GRIDDLE	ELECTROLUX	371037+371112	1 Ea
HK 16	GAS LAVA GRILL	ELECTROLUX	371044+371112	1 Ea
HK 17	4-OPEN BURNER GAS RANGE W/ GAS OVEN	ELECTROLUX	371002	1 Ea
HK 18	ELEC. SALAMANDER	ELECTROLUX	SALE 06 (775302)	1 Ea
HK 19	SALAMANDER SUPPORT	CUS TOM MADE	650x450x500	1 Ea
HK 20	SPARE ITEM			
HK 21	SPARE ITEM			
HK 22	SPARE ITEM			
HK 23	COUNTER TOP FREEZER, 1-DOOR	CUS TOM MADE	1000x750x850+150	1 Ea
HK 24	COUNTER TOP REFRIGERATOR, 1-DOOR & 2-DRAWER	CUS TOM MADE	1500x750x850+150	1 Ea
HK 25	WALL SHELF, 1-TIER	CUS TOM MADE	2550x350	1 Ea
HK 26	CORNER FILLER TOP	CUS TOM MADE	750x750x750+150	1 Ea
HK 27	ELEC. BAIN MARIE, 3-GN. 1/1 PAN SIZE	CUS TOM MADE	1200x750x850	1 Ea
HK 28	OVER SHELF, 2-TIER	CUS TOM MADE	1950x400x500+350	1 Ea
HK 29	PLATE WARMING CABINET	CUS TOM MADE	1400x750x850	1 Ea
HK 30	OVER SHELF, 2-TIER	CUS TOM MADE	1400x400x500+350	1 Ea
HK 31	ELEC. INFRARED HEATED LAMP	BERJAYA	IR1000	1 Ea
HK 32	SERVING CABINET	CUS TOM MADE	1675x400x750	2 Ea
HK 33	INSECT TRAP	P&L	EX408S	1 Ea
HK 34	SPARE ITEM			
HK 35	FLOOR GULLY W/ GRATING	CUS TOM MADE	1500x1500x150+100	1 Ea
HK 36	ELEC. COMBI OVEN, 10-GN. 1/1 B LW	ELECTROLUX	268202	1 Ea
HK 37	COMBI OVEN STAND	CUS TOM MADE	818x686x600	1 Ea
HK 38	GN. 1/1 TROLLEY, 18-TIER	CUS TOM MADE	4200x550x1650	1 Ea
HK 39	EXHAUST HOOD W/ FRESH-AIR RETURN	CUS TOM MADE	1100x1400x500	1 Ea
HK 40	WATER FILTER	EVERPURE	FOUNTAIN SMALL	1 Ea
HK 41	FIRE SUPPRESSION SYSTEM	PYROCHEM	KITCHEN KNIGHT II	1 Ea
HK 42	SPARE ITEM			
HK 43	SPARE ITEM			

VEGETABLE PREPARATION				
VP 01	HAND WASH SINK CABINET, KNEE OPERATED	LEECO	ST-4545	1 Ea
VP 02	WORK TABLE W/ UNDER SHELF	CUS TOM MADE	1724x750x850+150	1 Ea
VP 03	PORTABLE SCALE, MAX. 6KG., E=1G	DGI	DS-673	1 Ea
VP 04	WALL SHELF, 1-TIER	CUS TOM MADE	2475x350	1 Ea
VP 05	WORK TABLE W/ BRACING	CUS TOM MADE	1074x750x850+150	1 Ea
VP 06	MOBILE GARBAGE BIN	CUS TOM MADE	Ø435x550+110	1 Ea
VP 07	GREASE TRAP	CUS TOM MADE	300x400x400	1 Ea
VP 08	SINK TABLE, 2-BOWL	CUS TOM MADE	2025x750x850+150	1 Ea
VP 09	FLOOR GULLY W/ GRATING	CUS TOM MADE	500x300x150+100	1 Ea
VP 10	UPRIGHT REFRIGERATOR, 4-SOLID HALF DOOR	CUS TOM MADE	1320x750x2050	1 Ea
VP 11	SPARE ITEM			
VP 12	SPARE ITEM			
VP 13	SPARE ITEM			
VP 14	CORNER FILLER TOP	CUS TOM MADE	750x750x850+150	2 Ea
VP 15	WALL SHELF, 1-TIER	CUS TOM MADE	1875x350	1 Ea
VP 16	FOOD PROCESSOR	ROBOT COUPE	R-301 ULTRA	1 Ea
VP 17	VACUUM MACHINE	ELECTROLUX	600038	1 Ea
VP 18	MOBILE TABLE W/ UNDER SHELF	CUS TOM MADE	500x750x650	1 Ea
VP 19	SPARE ITEM			
VP 20	SPARE ITEM			
FISH PREPARATION				
FP 01	UPRIGHT FREEZER, 2-SOLID HALF DOOR	CUS TOM MADE	680x750x2050	1 Ea
FP 02	UPRIGHT REFRIGERATOR, 2-SOLID HALF DOOR	CUS TOM MADE	680x750x2050	1 Ea
FP 03	FLOOR GULLY W/ GRATING	CUS TOM MADE	500x300x150+100	1 Ea
FP 04	SINK TABLE, 1-BOWL	CUS TOM MADE	1750x750x850+150	1 Ea
FP 05	WORK TABLE W/ UNDER SHELF	CUS TOM MADE	1000x750x850+150	1 Ea
FP 06	MOBILE GARBAGE BIN	CUS TOM MADE	Ø435x550+110	1 Ea
FP 07	WALL SHELF, 1-TIER	CUS TOM MADE	1765x350	1 Ea
FP 08	CORNER FILLER TOP	CUS TOM MADE	750x750x850+150	1 Ea
FP 09	WALL SHELF, 1-TIER	CUS TOM MADE	2150x350	1 Ea
FP 10	GREASE TRAP	CUS TOM MADE	300x400x400	1 Ea
FP 11	SPARE ITEM			
FP 12	SPARE ITEM			
MEAT PREPARATION				
MP 01	UPRIGHT FREEZER, 2-SOLID HALF DOOR	CUS TOM MADE	680x750x2050	1 Ea
MP 02	UPRIGHT REFRIGERATOR, 2-SOLID HALF DOOR	CUS TOM MADE	680x750x2050	1 Ea
MP 03	FLOOR GULLY W/ GRATING	CUS TOM MADE	500x300x150+100	1 Ea
MP 04	SINK TABLE, 1-BOWL	CUS TOM MADE	1750x750x850+150	1 Ea
MP 05	WORK TABLE W/ UNDER SHELF	CUS TOM MADE	1000x750x850+150	1 Ea
MP 06	MOBILE GARBAGE BIN	CUS TOM MADE	Ø435x550+110	1 Ea
MP 07	MEAT SLICER	POWERLINE	PS-12	1 Ea
MP 08	WALL SHELF, 1-TIER	CUS TOM MADE	1765x350	1 Ea
MP 09	MEAT MINCER	POWERLINE	PG12FS	1 Ea
MP 10	CORNER FILLER TOP	CUS TOM MADE	750x750x850+150	1 Ea
MP 11	WALL SHELF, 1-TIER	CUS TOM MADE	2150x350	1 Ea
MP 12	GREASE TRAP	CUS TOM MADE	300x400x400	1 Ea
MP 13	SPARE ITEM			
MP 14	SPARE ITEM			

DISH & POT WASH AREA				
WA 01	SINK TABLE, 2-BOWL	CUS TOM MADE	1800x750x850+150	1 Ea
WA 02	WALL SHELF, 1-TIER	CUS TOM MADE	1800x350	1 Ea
WA 03	GREASE TRAP	CUS TOM MADE	300x400x400	2 Ea
WA 04	MOBILE GARBAGE BIN	CUS TOM MADE	Ø435x550+110	2 Ea
WA 05	FLOOR GULLY W/ GRATING	CUS TOM MADE	500x300x150+100	2 Ea
WA 06	DIRTY DISH TABLE W/ PRE-RINSE UNIT	CUS TOM MADE	1585x750x900+150	1 Ea
WA 07	WALL RACK SHELF	CUS TOM MADE	700x425	2 Ea
WA 08	DISH WASHER, HOOD TYPE	ELECTROLUX	505071	1 Ea
WA 09	CONDENSATE CANOPY W/ FRESH-AIR RETURN	CUS TOM MADE	1000x1000x300	1 Ea
WA 10	CLEAN DISH TABLE W/ RACK SLIDE	CUS TOM MADE	900x750x900+150	1 Ea
WA 11	SLATED SHELF, 4-TIER	CUS TOM MADE	1500x500x1500	2 Ea
WA 12	SLATED SHELF, 4-TIER	CUS TOM MADE	1000x500x1500	1 Ea
WA 13	INSECT TRAP	P&L	EX408S	1 Ea
WA 14	SPARE ITEM			
WA 15	SPARE ITEM			
ICE PRODUCTION				
IP 01	CUBE ICE MACHINE, 320 KG. DAY	SCOTSMAN	MY 1006AS-SB330	1 Ea
IP 02	WATER FILTER W/UV SYSTEM	EVERPURE	OCT-7CB5K+PF20+S1Q-PA	1 Ea
IP 03	FLOOR GULLY W/ GRATING	CUS TOM MADE	500x300x150+100	1 Ea
IP 04	SPARE ITEM			
IP 05	SPARE ITEM			
GENERAL CHILLER W/ SYSTEM				
GC 01	GENERAL CHILLER W/ SYSTEM	CUS TOM MADE	2950x1750x2600 (OD.)	1 Ea
GC 02	GN. 1/1 TROLLEY, 18-TIER	CUS TOM MADE	4200x550x1650	1 Ea
GC 03	SLATED SHELF, 4-TIER	CUS TOM MADE	1000x500x1500	1 Ea
GC 04	SLATED SHELF, 4-TIER	CUS TOM MADE	1500x500x1500	1 Ea
GC 05	FLOOR GULLY W/ GRATING	CUS TOM MADE	1500x500x150+100	1 Ea
GC 06	SPARE ITEM			
GENERAL FREEZER W/ SYSTEM				
GF 01	GENERAL FREEZER W/ SYSTEM	CUS TOM MADE	2950x1450x2600 (OD.)	1 Ea
GF 02	SLATED SHELF, 4-TIER	CUS TOM MADE	1000x500x1500	1 Ea
GF 03	SLATED SHELF, 4-TIER	CUS TOM MADE	1100x500x1500	1 Ea
GF 04	SLATED SHELF, 4-TIER	CUS TOM MADE	1200x500x1500	1 Ea
GF 05	SPARE ITEM			
GF 06	SPARE ITEM			

UPDATE DRAWING : 160519


 <p>Thanakorn Holding Co., Ltd. 458/24-25 Mooban Kulapapruk M.1 Rattana Raj Road, T. Bangbor A. Bangbor Samutprakarn 10560, Thailand Tel : +662-3381465, Fax : +662-3381849 E-Mail : gm@thanakornholding.com</p>	PROJECT NAME:	Ibis Styles Hotel @ Prakanong			DRAWING TITLE:	MAIN KITCHEN		DRAWING DETAIL			
	REV	DATE	CHK	DESCRIPTION	LOCATION:	7th. FLOOR PLAN		CAD FILE	BS-TL-444-410-10019-DWG	DATE:	150105
					SHEET CONTENTS:	EQUIPMENT LIST		SCALE	K	CHECKED	APPROVED
								PROJECT	IBS-1501	SHEET NO.	DWG. NO.

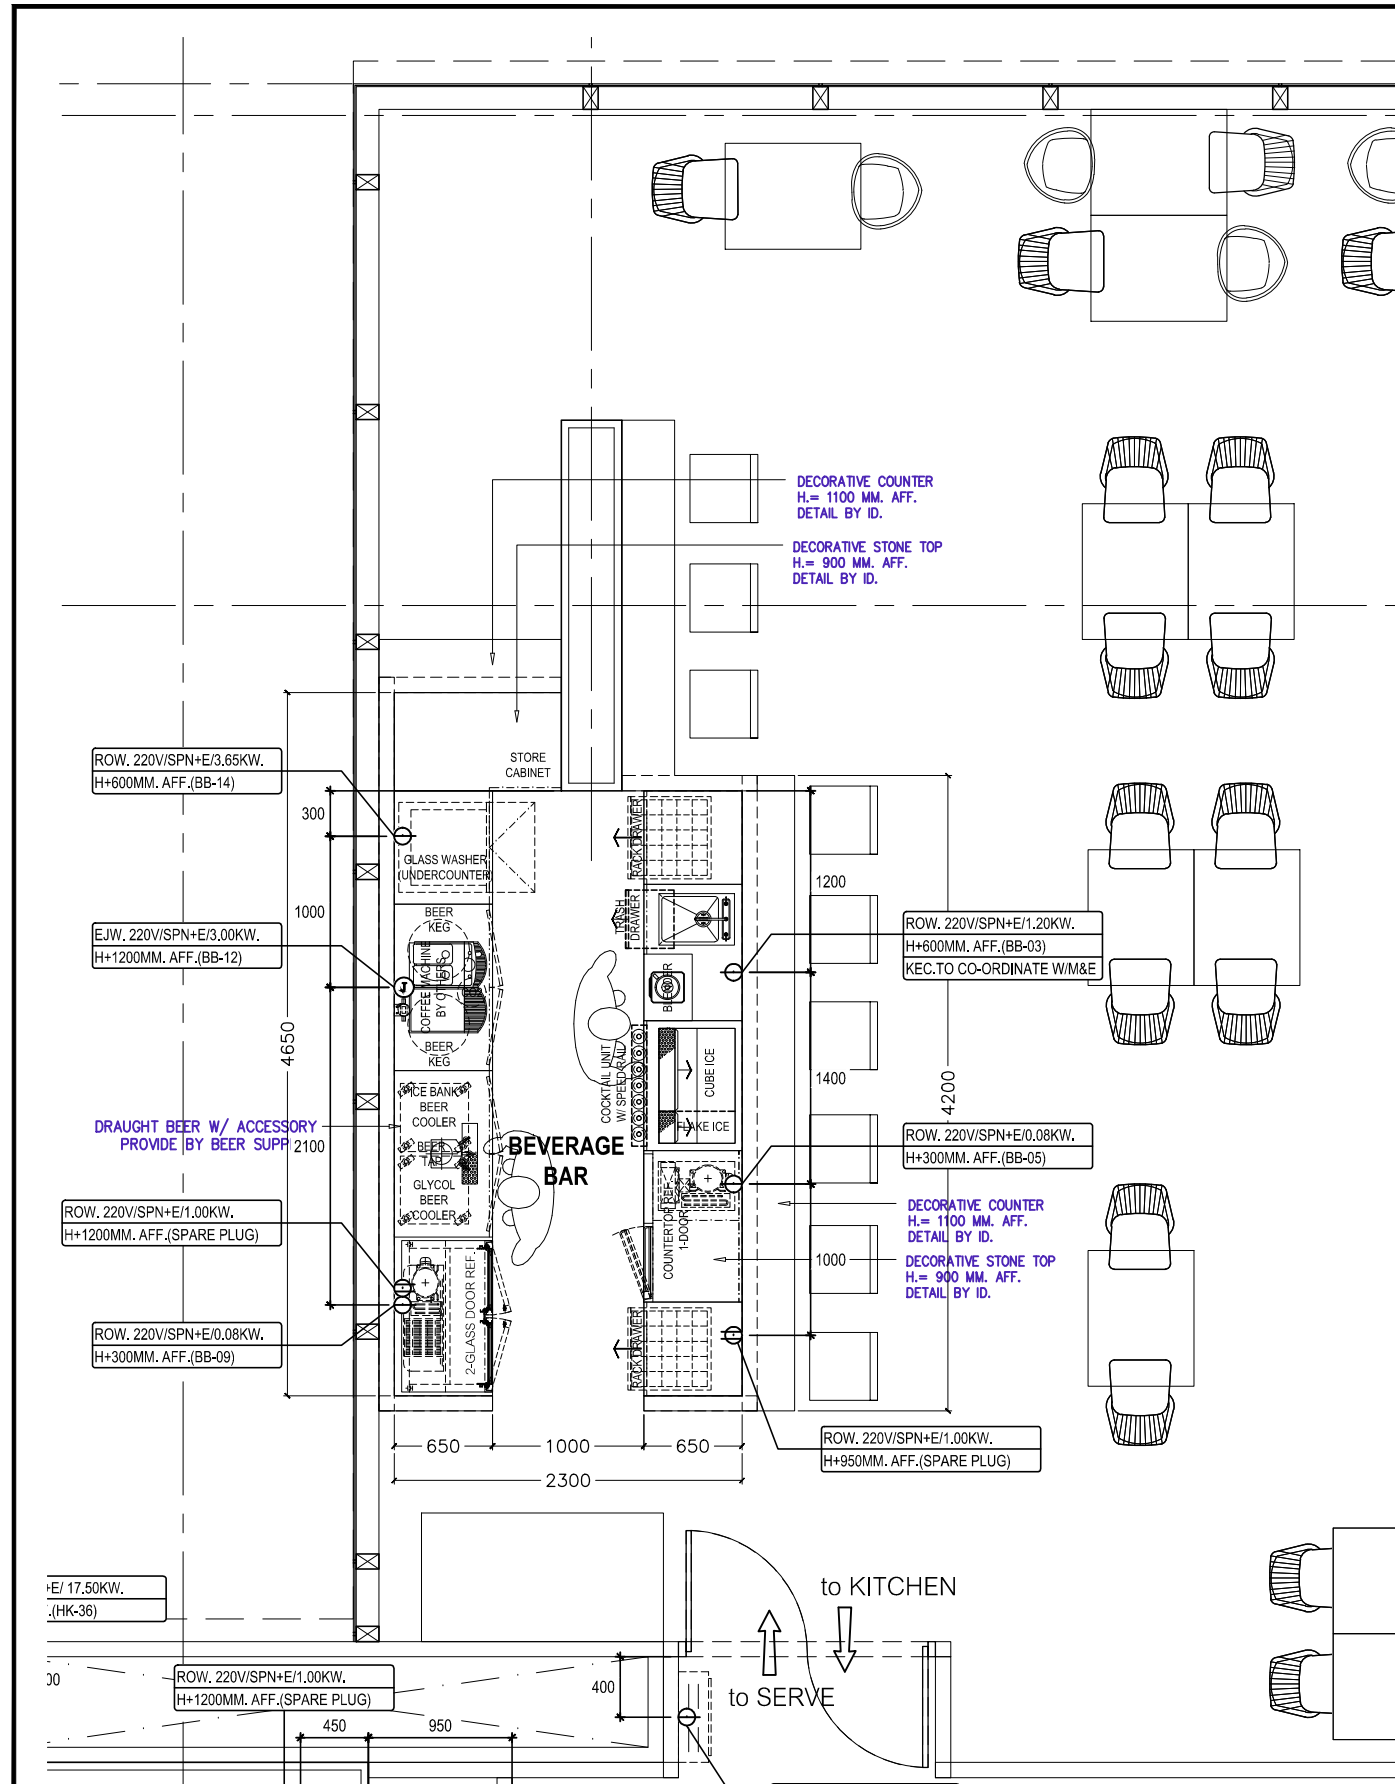

LEGEND FOR ELECTRICAL SERVICES		
⊖	ROW	Electrical Receptacle Outlet on Wall w/Isolator *
⊖	ROW	Electrical Duplex Receptacle Outlet on Wall w/Isolator *
⊖	POW	Power Plug Electrical Outlet on Wall w/Isolator *
⊖	POC	Power Plug Electrical Outlet from Ceiling w/Isolator *
⊖	POF	Power Plug Electrical Outlet on Floor w/Isolator *
⊖	ROF	Electrical Receptacle Outlet on Floor w/Isolator * (or Free Cable Penetration From Floor + Receptacle Outlet To Be Installed Inside Equipment)
⊖	ROC	Electrical Receptacle Outlet from Ceiling w/Isolator *
⊖	EJW	Electrical Junction Box on Wall w/Isolator * (1500 mm. Free Cable End)
⊖	EJF	Electrical Junction Box on Floor w/Isolator * (1500 mm. Free Cable End)
⊖	EJC	Electrical Junction Box from Ceiling w/Isolator * (1500 mm. Free Cable End)
⊖	RPF	Electrical Receptacle Outlet on Floor w/Isolator * (Flush Type Water Proof)
	SPN	Single Phase Three Wire
	TPN	Three Phase Five Wire
	FC	Free Cable 1500 mm (Penetration Through Floor By Rigid Conduit) , KEC. To Co-Ordinate w/ M&E , Refer To Typical Detail
	*	Isolator / On-Off Switch & Wiring , Per Local Regulation Isolator / On-Off Switch
		Location & Detail To Be Co-Ordinated w/ M&E Contractor & KEC.
	FFL	Finish Floor Level
	AFF.	Above Finished Floor

UPDATE DRAWING : 160519

<p>Thanakorn Holding Co.,Ltd. 458/24-25 Mooban Kulapaprak M.1 Rattana Raj Road , T.Bangbor A.Bangbor Samuiprakarn 10560 , Thailand Tel : +662-3381465 , Fax : +662-3381849 E-Mail : gm@thanakornholding.com</p>	<p>PROJECT NAME:</p> <p>Ibis Styles Hotel @ Prakanong</p>	REV	DATE	CHK	DESCRIPTION	DRAWING TITLE:	MAIN KITCHEN	DRAWING DETAIL				
		LOCATION:						7th. FLOOR PLAN	CAD FILE	BS-7FL-404-4E-410-160519.DWG	DATE	150105
		SHEET CONTENTS:						ELECTRICAL ROUGH-IN	SCALE	1:50	DRAWN	K
							PRODUCT	IBS-1501	SHEET NO.		DRG. NO.	KE-03

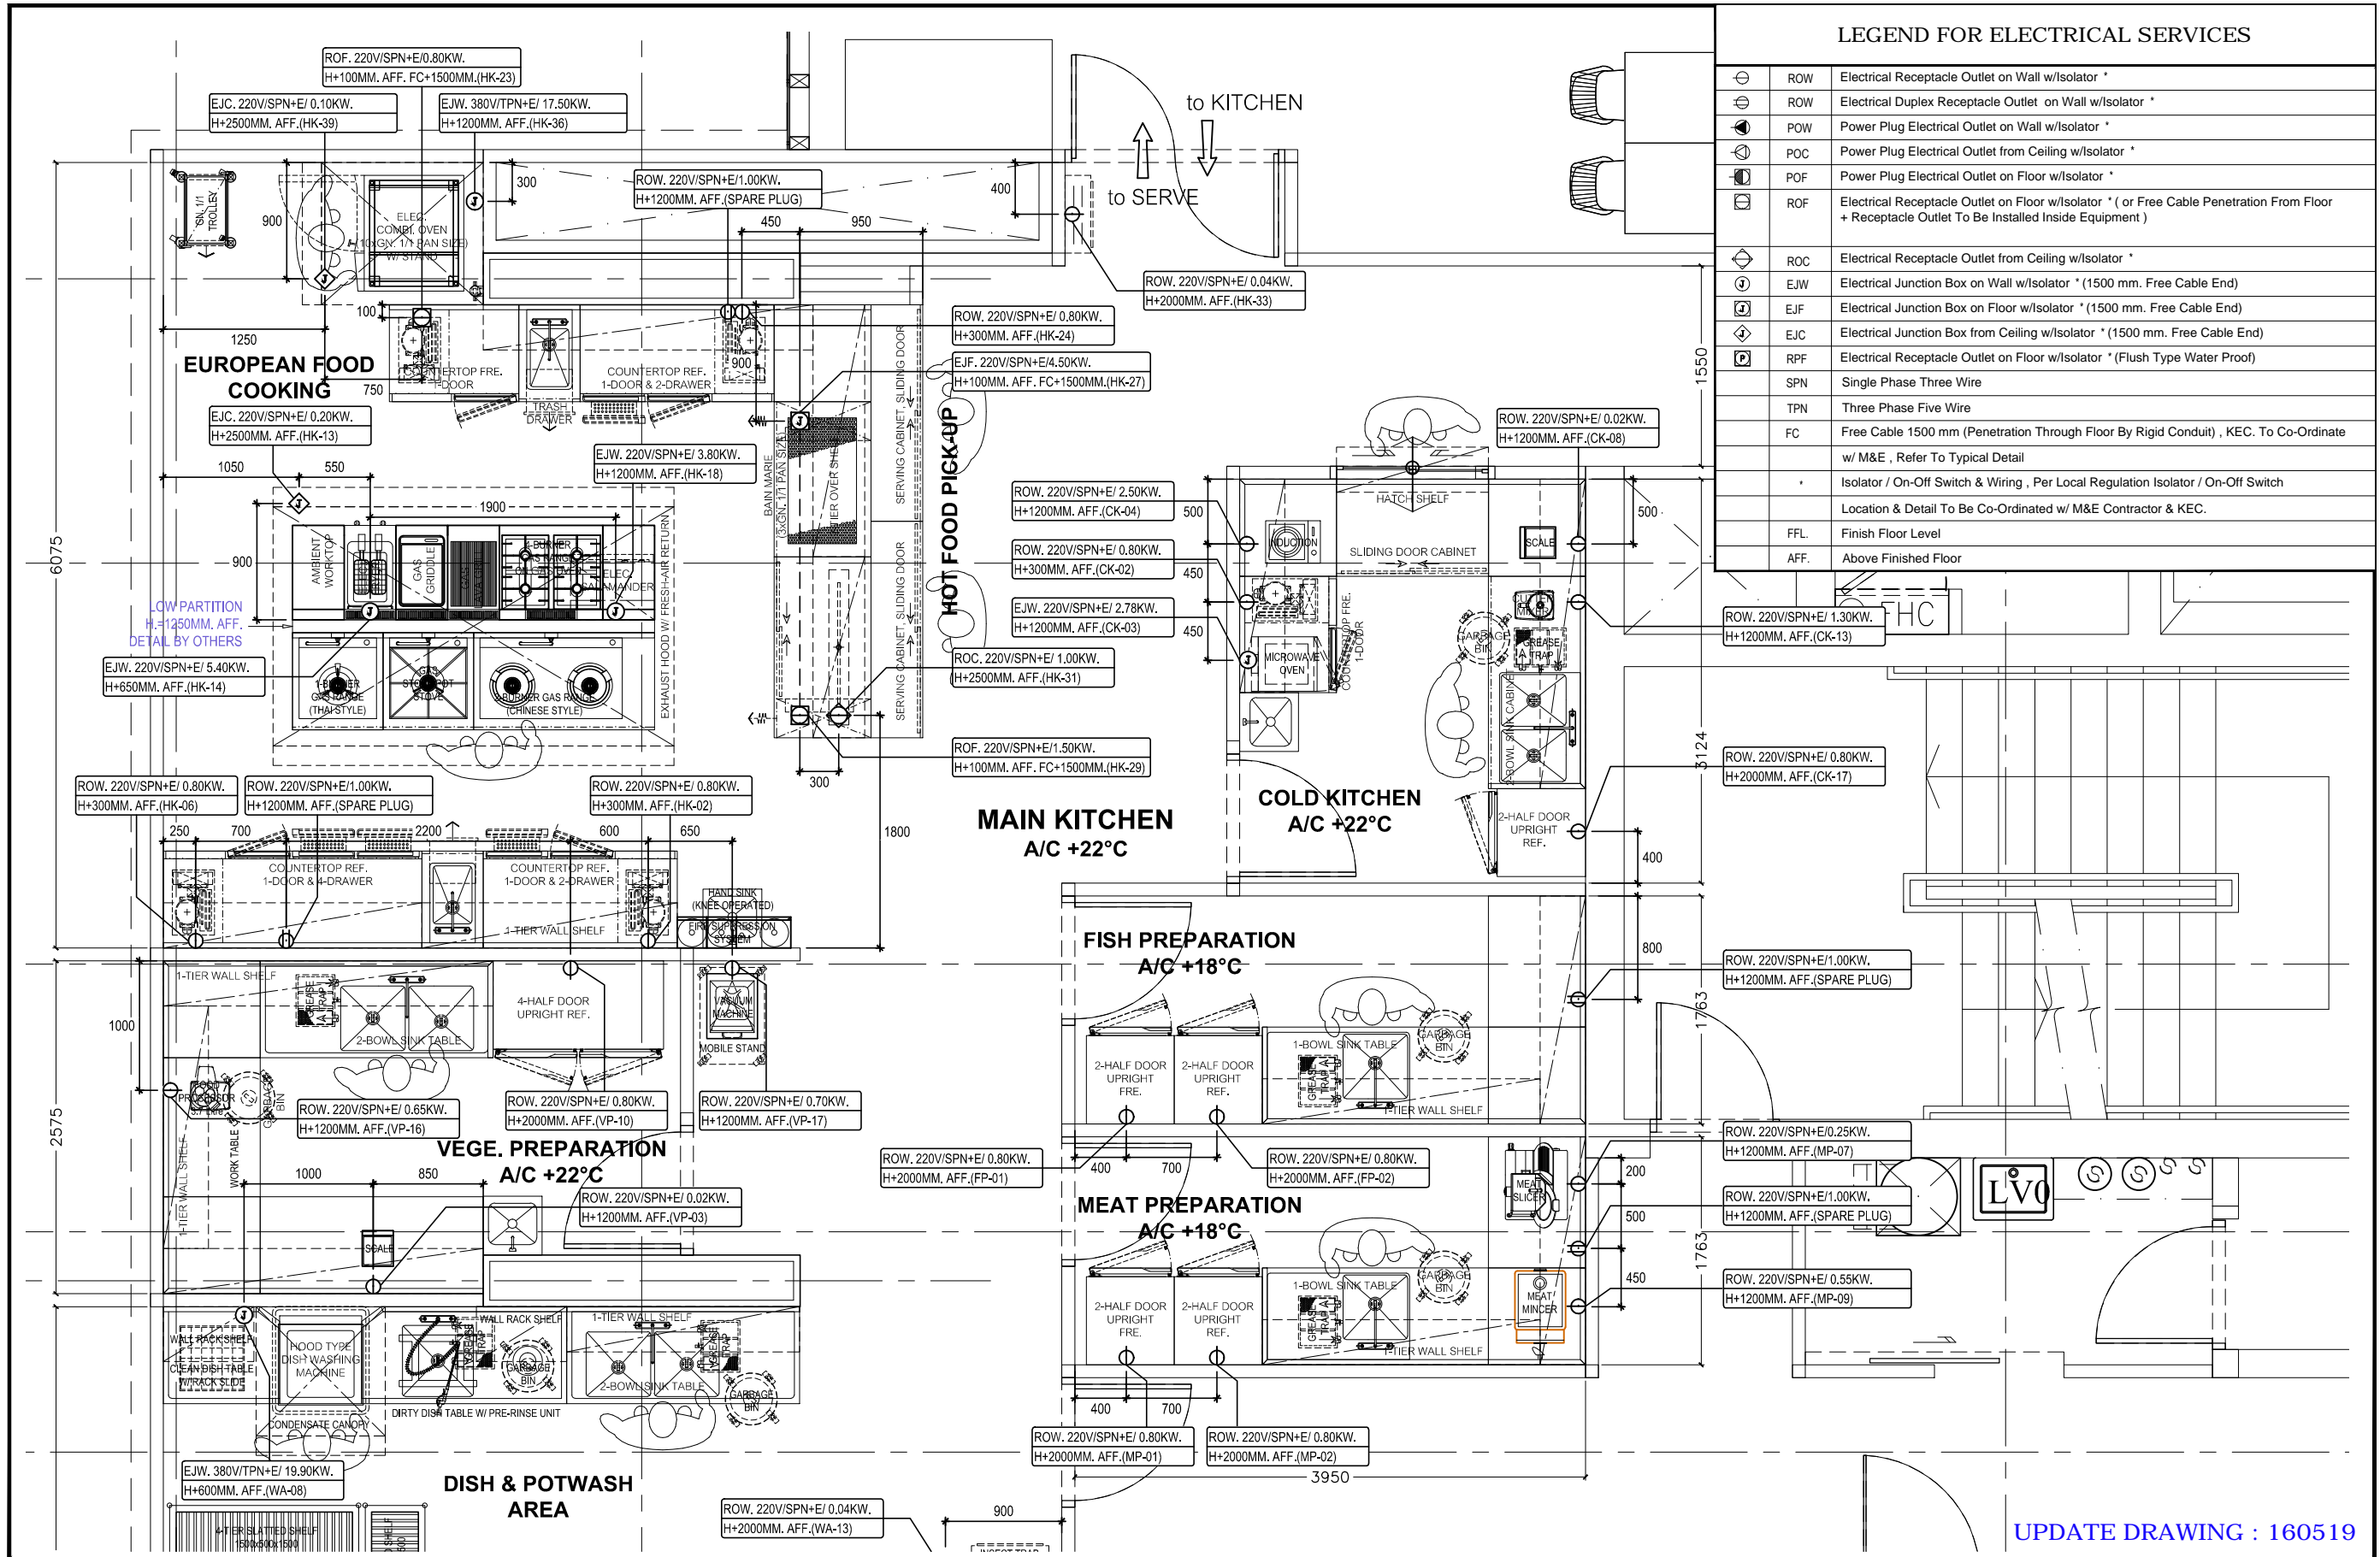


LEGEND FOR ELECTRICAL SERVICES

⊖	ROW	Electrical Receptacle Outlet on Wall w/Isolator *
⊖	ROW	Electrical Duplex Receptacle Outlet on Wall w/Isolator *
⊖	POW	Power Plug Electrical Outlet on Wall w/Isolator *
⊖	POC	Power Plug Electrical Outlet from Ceiling w/Isolator *
⊖	POF	Power Plug Electrical Outlet on Floor w/Isolator *
⊖	ROF	Electrical Receptacle Outlet on Floor w/Isolator * (or Free Cable Penetration From Floor + Receptacle Outlet To Be Installed Inside Equipment)
⊖	ROC	Electrical Receptacle Outlet from Ceiling w/Isolator *
⊖	EJW	Electrical Junction Box on Wall w/Isolator * (1500 mm. Free Cable End)
⊖	EJF	Electrical Junction Box on Floor w/Isolator * (1500 mm. Free Cable End)
⊖	EJC	Electrical Junction Box from Ceiling w/Isolator * (1500 mm. Free Cable End)
⊖	RPF	Electrical Receptacle Outlet on Floor w/Isolator * (Flush Type Water Proof)
⊖	SPN	Single Phase Three Wire
⊖	TPN	Three Phase Five Wire
⊖	FC	Free Cable 1500 mm (Penetration Through Floor By Rigid Conduit), KEC. To Co-Ordinate w/ M&E, Refer To Typical Detail
⊖	*	Isolator / On-Off Switch & Wiring, Per Local Regulation Isolator / On-Off Switch
⊖		Location & Detail To Be Co-Ordinated w/ M&E Contractor & KEC.
⊖	FFL	Finish Floor Level
⊖	AFF.	Above Finished Floor

UPDATE DRAWING : 160519


<p>Thanakorn Holding Co., Ltd. 458/24-25 Mooban Kulaparak M.1 Rattana Raj Road, T. Bangbor A. Bangbor Samuiprakarn 10560, Thailand Tel : +662-3381465, Fax : +662-3381849 E-Mail : gm@thanakornholding.com</p>	PROJECT NAME:	Ibis Styles Hotel @ Prakanong	REV	DATE	CHK	DESCRIPTION	DRAWING TITLE:	MAIN KITCHEN	DRAWING DETAIL						
							LOCATION:	7th. FLOOR PLAN	CAD FILE	BS-711-441-410-10019.DWG	DATE:	150105			
							SHEET CONTENTS:	ELECTRICAL ROUGH-IN	SCALE	1:50	DESIGNER	K	CHECKED	APPROVED	
									PRODUCT	IBS-1501	SHEET NO.		DRG. NO.		KEY

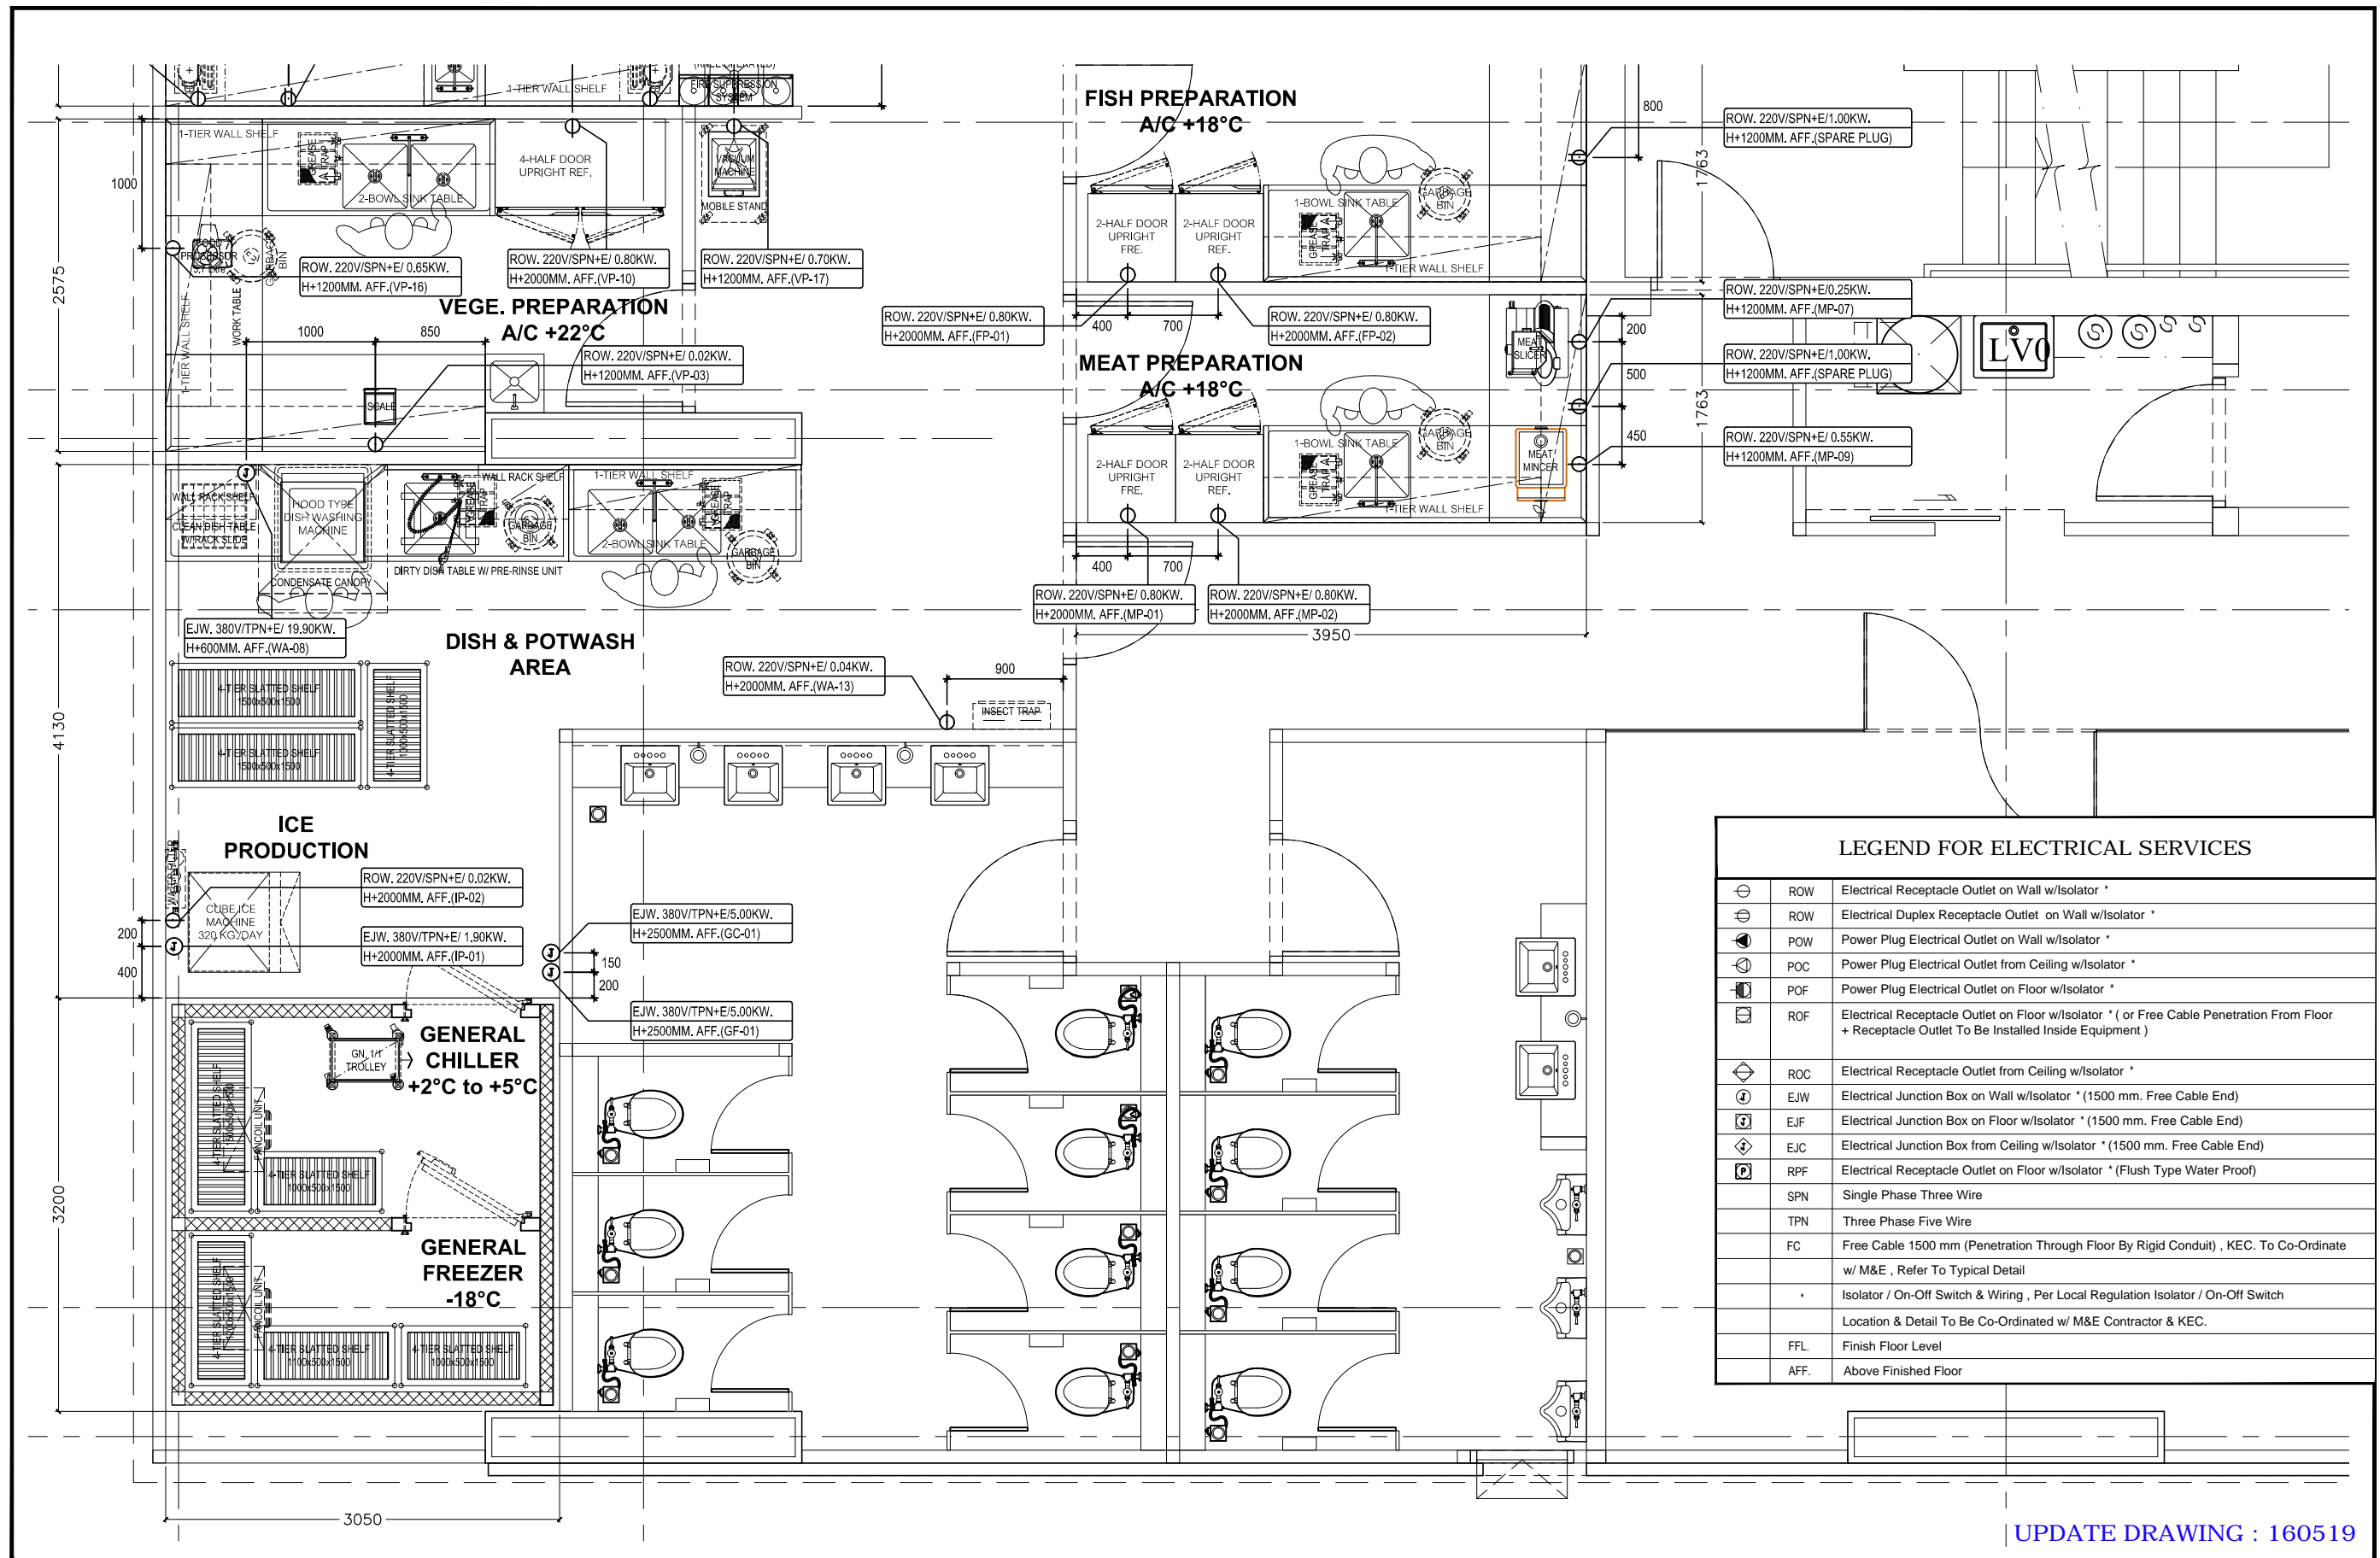

UPDATE DRAWING : 160519

LEGEND FOR PLUMBING SERVICES

○	CWF.	Cold Water Outlet on Floor Ø12 mm., Ø19 mm. with Valve (Soft Water)
○	CWW.	Cold Water Outlet on Wall Ø12 mm., Ø19 mm. with Valve (Soft Water)
●	HWF.	Hot Water Outlet on Floor Ø12 mm., Ø19 mm. with Valve (Soft Water)
●	HWW.	Hot Water Outlet on Wall Ø12 mm., Ø19 mm. with Valve (Soft Water)
Water hardness for commercial kitchens & laundries should not exceed 2.5 grains per gallon (43 ppm) Water softening treatment equipment should be installed if water analysis indicates water hardness exceeding 1.0 grains per gallon, (17 ppm) expressed as calcium carbonate.		
All Water Pressure at 40-80 psi		
Hot Water Supply Temperature at 55°C. to 60°C. and		
Soft Water Total Hardness 0-20 ppm. as CaCO ₃		
⊕	WDF.	Waste Drain on Floor Ø38 mm.
⊕	WDF.	Waste Drain on Floor Ø50 mm.
⊕	CD.	Condensed Drain on Floor Ø19 mm.
⊕	CD.	Condensed Drain on Floor Ø38 mm.
⊕	WDW.	Waste Drain on Wall Ø38 mm.
⊕	WDW.	Waste Drain on Wall Ø50 mm.
⊕	GOF.	Gas Outlet on Floor with Ball Valve (and Pressure Gauge for Each Kitchen Hight & Low Pressure)
⊕	LO.	Low Pressure With Regulator (Pressure 0.5-1 psi)
⊕	HI.	High Pressure (Pressure 10-20 psi)
▽	FFL.	Finish Floor Level
▲	AFF.	Above Finished Floor
⊕	SS.	Steam Supply
⊕	SR.	Steam Return

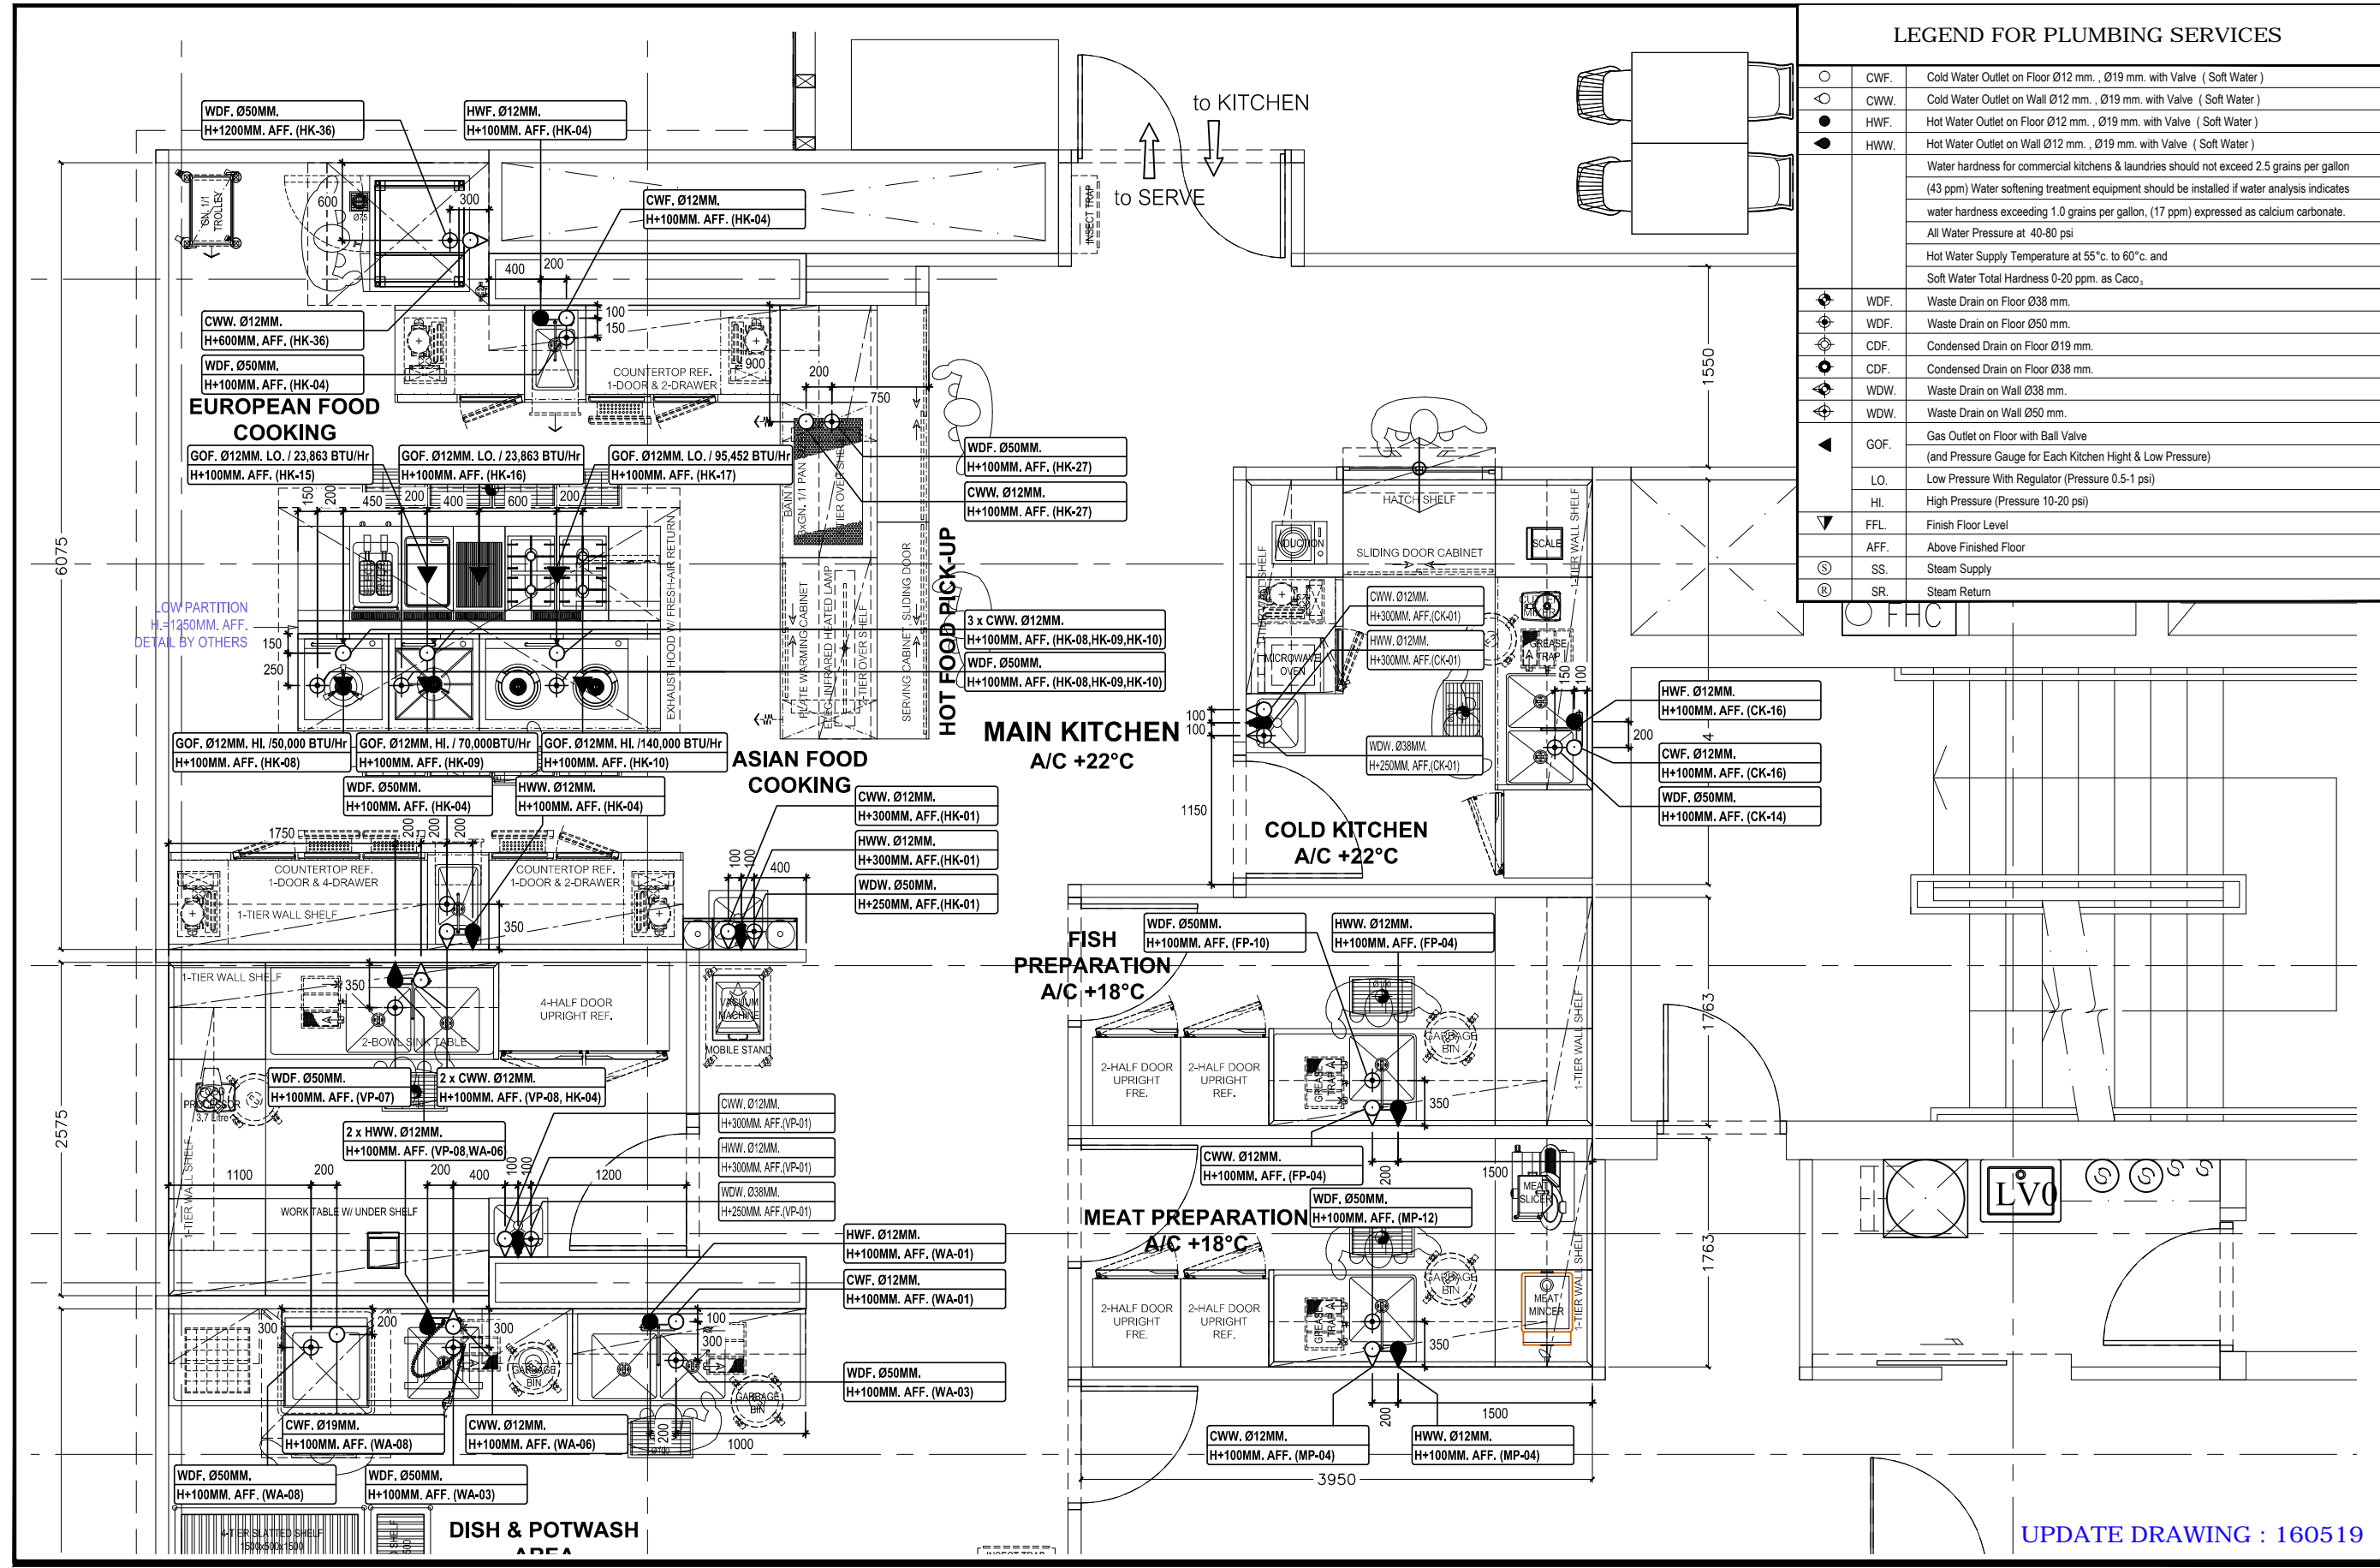

UPDATE DRAWING : 160519



 Thanakorn Holding Co., Ltd.
 458/24-25 Mooban Kulapaprak
 M.1 Rattana Raj Road, T. Bangbor A. Bangbor
 Samuiprakarn 10560, Thailand
 Tel : +662-3381465, Fax : +662-3381849
 E-Mail : gm@thanakornholding.com

PROJECT NAME:
Ibis Styles Hotel @ Prakanong


REV	DATE	CHK	DESCRIPTION

DRAWING TITLE:	MAIN KITCHEN
LOCATION:	7th. FLOOR PLAN
SHEET CONTENTS:	PLUMBING ROUGH-IN

DRAWING DETAIL	
CAD FILE	BS-7FL-404-404-160519.DWG
SCALE	1:50
DESIGNER	K
CHECKED	
APPROVED	
DATE	150105
PROJECT	IBS-1501
SHEET NO.	
DWG. NO.	
KP-04	

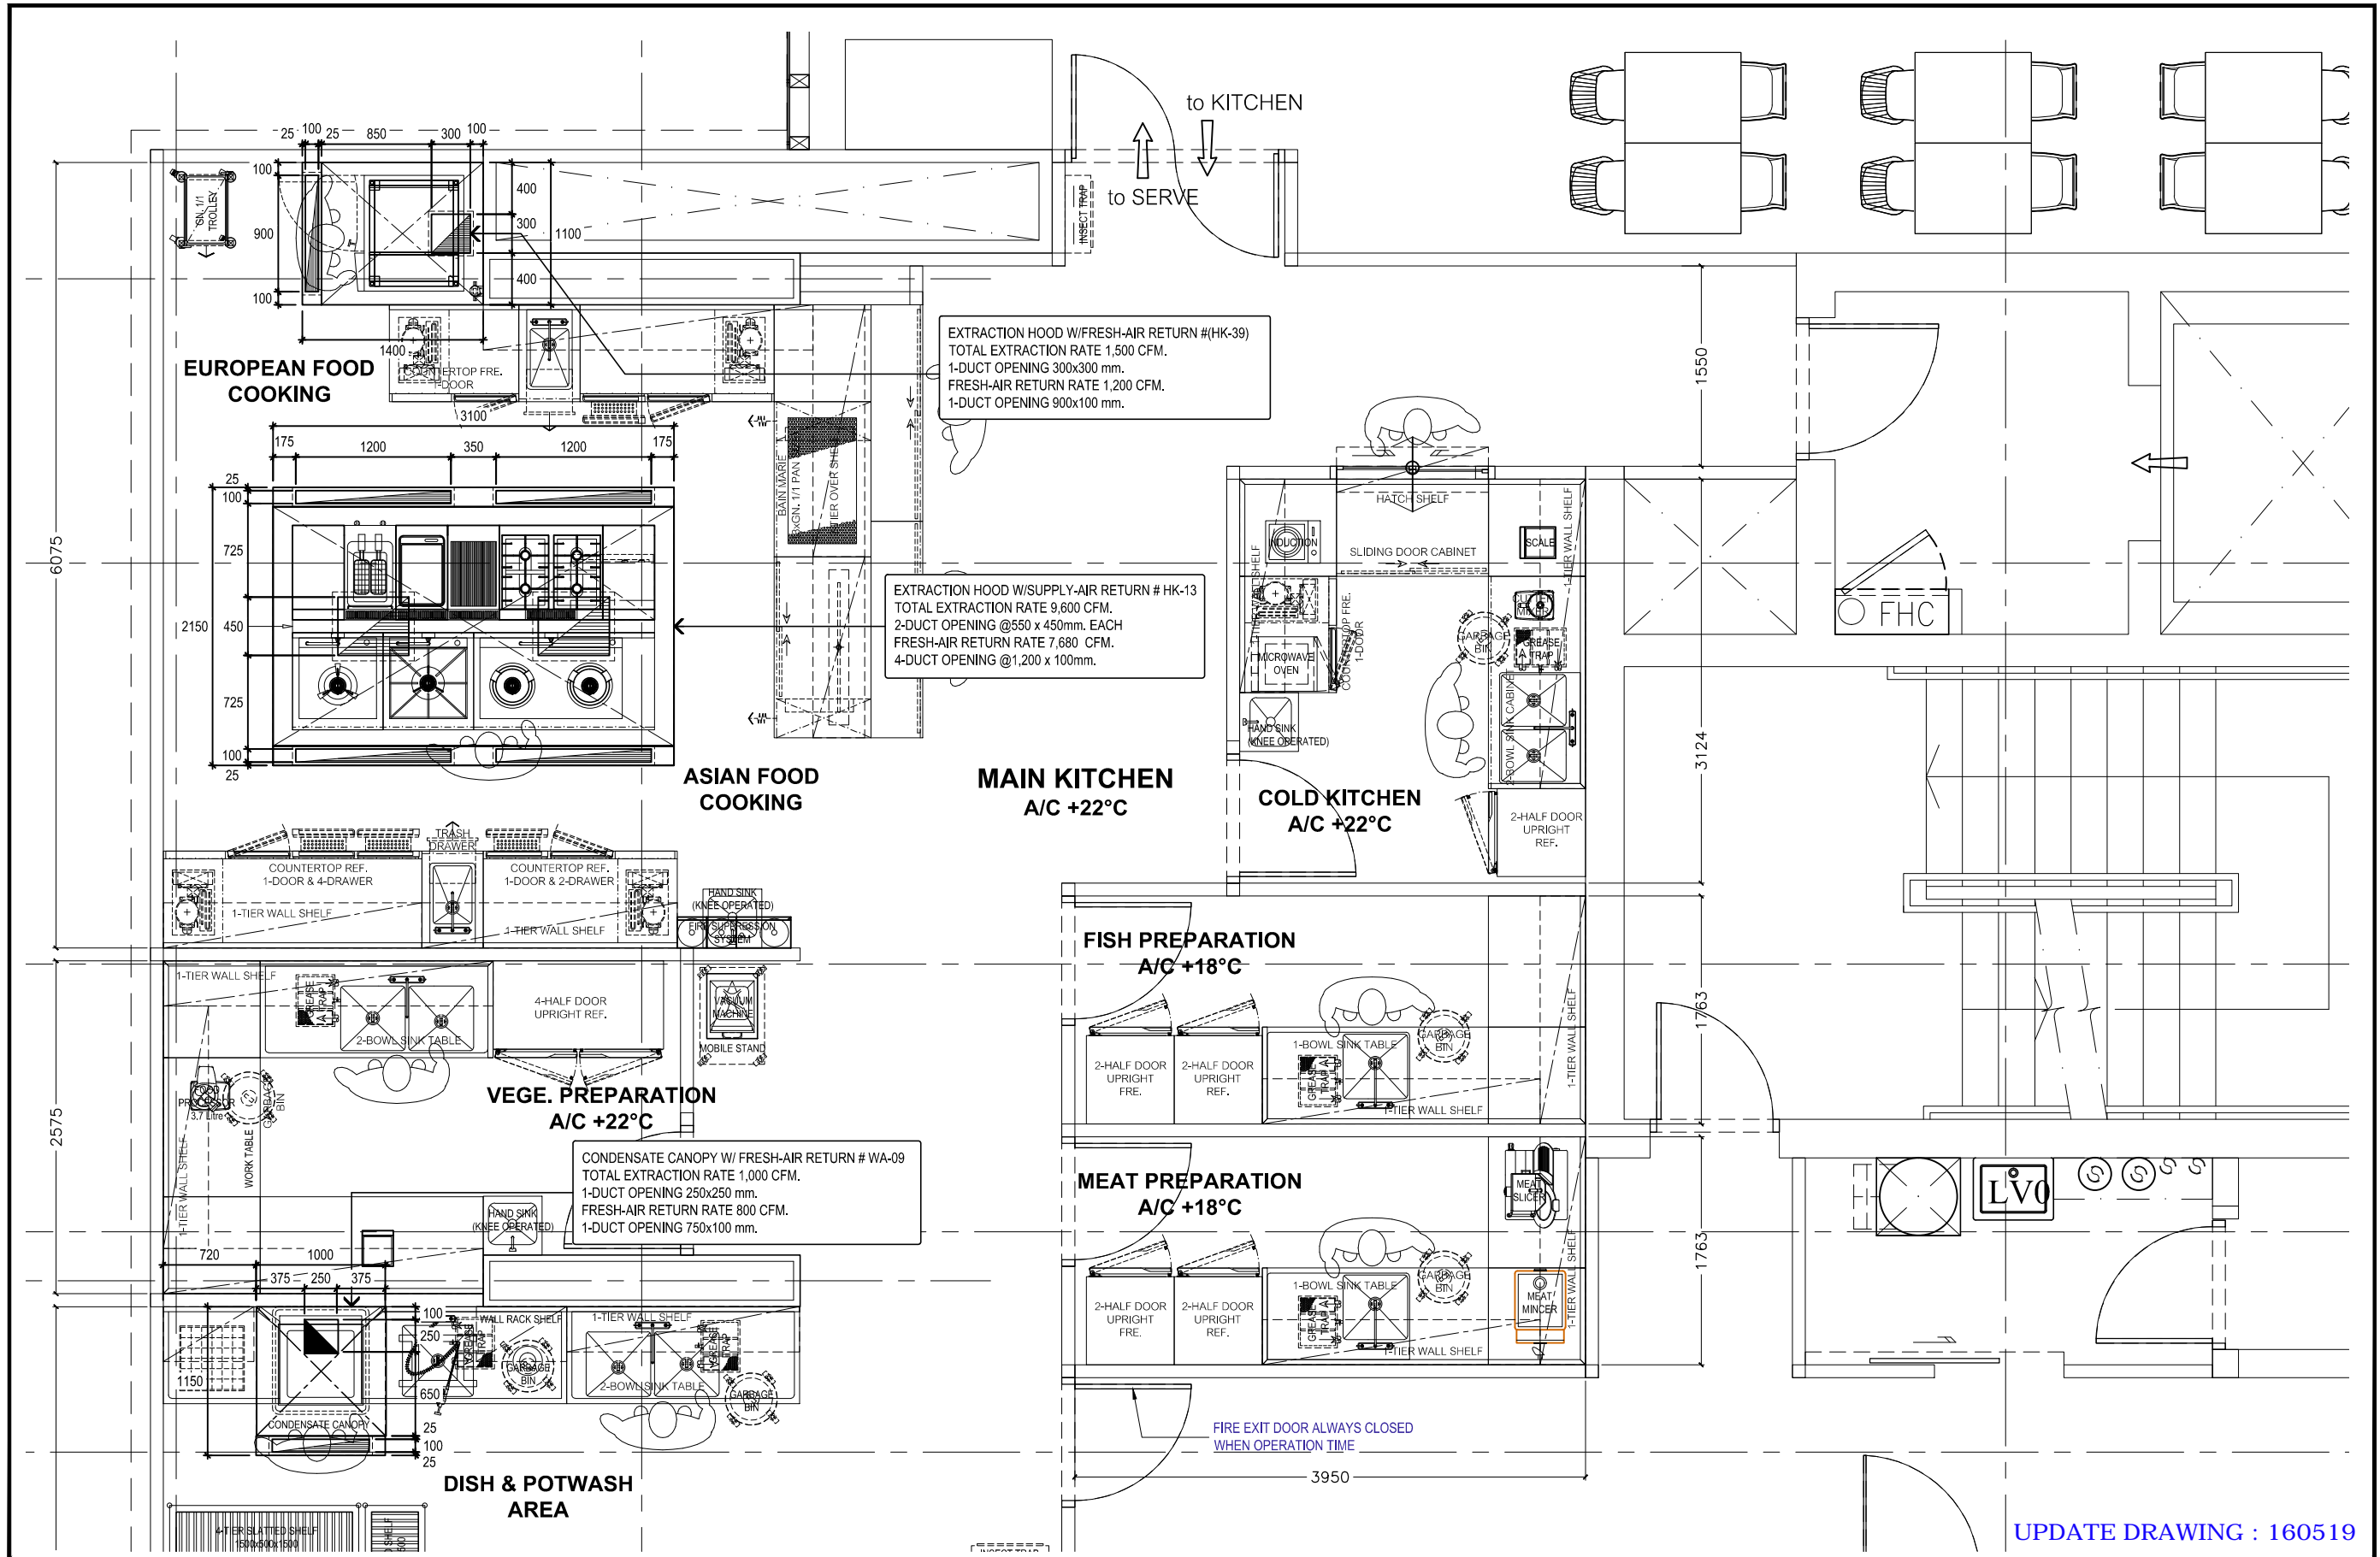

<p>Thanakorn Holding Co., Ltd. 458/24-25 Moobaan Kulapapruk M.1 Rattianaraj Road, T. Bangbor A. Bangbor Samutprakarn 10560, Thailand Tel : +662-3381465, Fax : +662-3381849 E-Mail : gm@thanakornholding.com</p>	PROJECT NAME:	<p>Ibis Styles Hotel @ Prakanong</p>	REV	DATE	CHK	DESCRIPTION	DRAWING TITLE:	<p>MAIN KITCHEN</p>	DRAWING DETAIL			
									LOCATION:	<p>7th. FLOOR PLAN</p>	CAD FILE	BS-7FL-404-404-10219.DWG
							SHEET CONTENTS:	<p>HVAC ROUGH-IN</p>	SCALE		K	CHECKED
									PRODUCT	1:50	SHEET NO.	DRG. NO.
									IBS-1501			


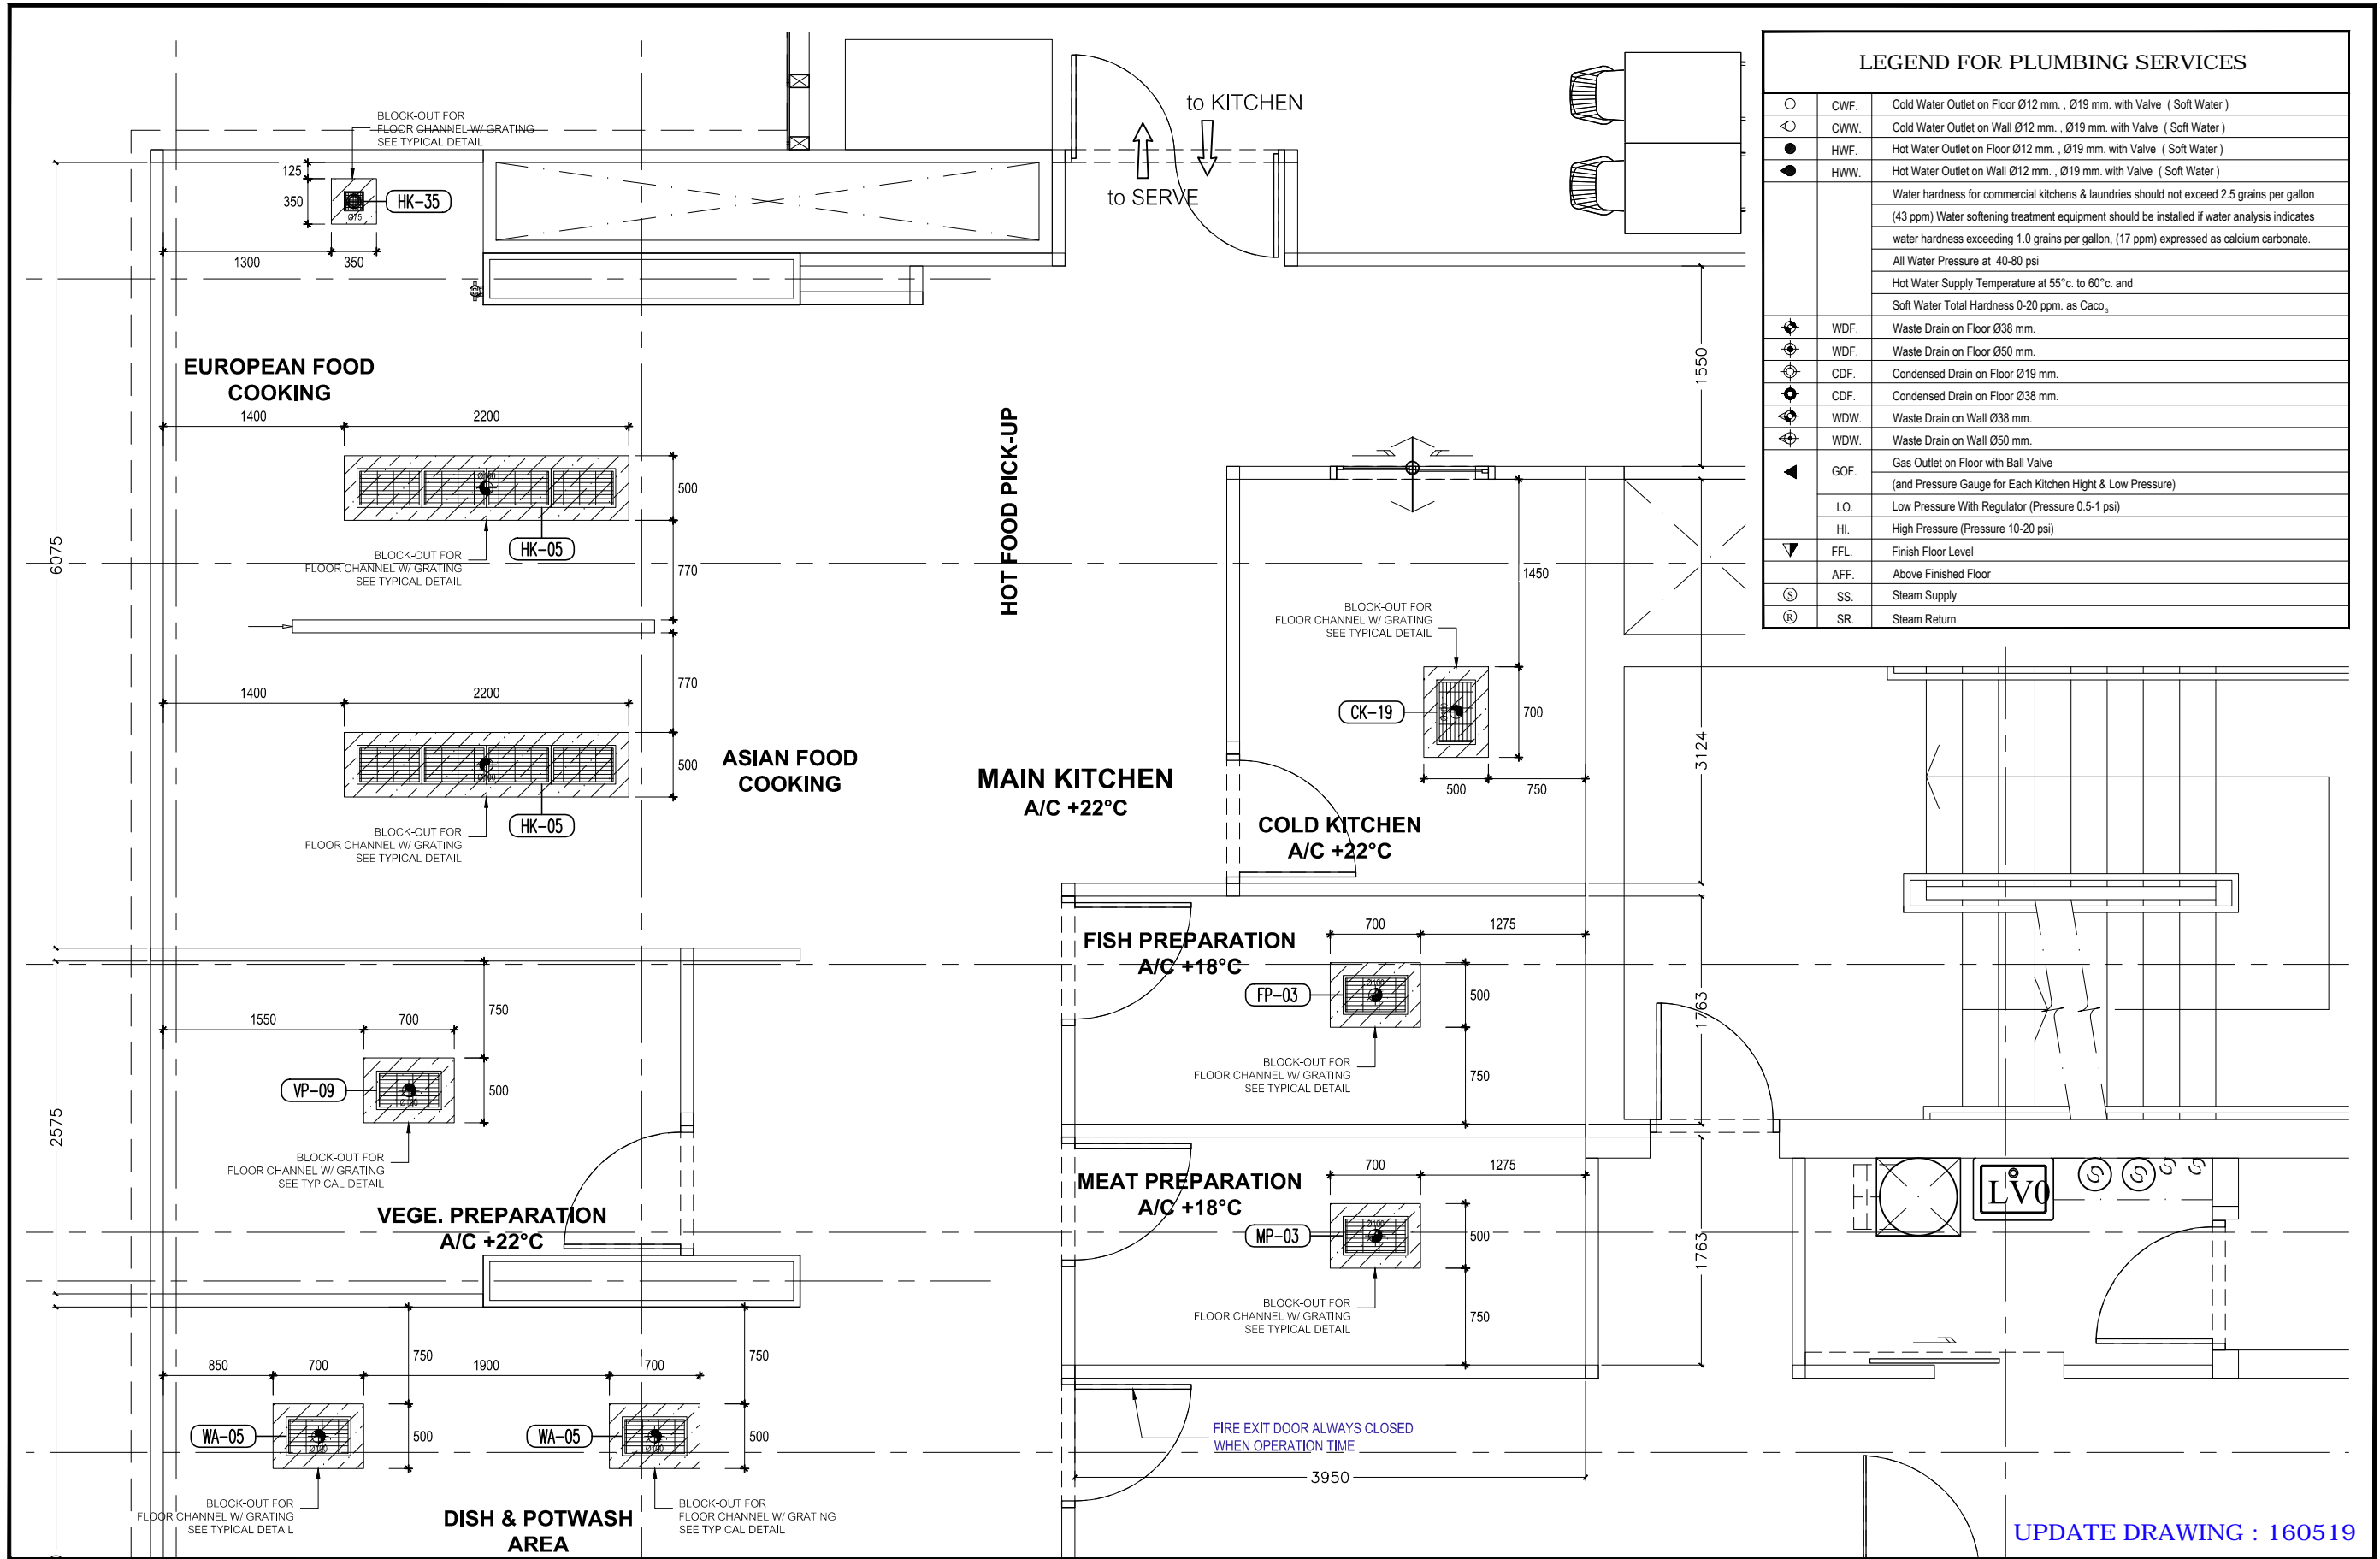


UPDATE DRAWING : 160519

<p>Thanakorn Holding Co.,Ltd. 458/24-25 Mooban Kulapapruk M.1 Rattianaraj Road , T.Bangbor A.Bangbor Samutprakarn 10560 , Thailand Tel : +662-3381465 , Fax : +662-3381849 E-Mail : gm@thanakornholding.com</p>	PROJECT NAME: Ibis Styles Hotel @ Prakanong	REV	DATE	CHK	DESCRIPTION	DRAWING TITLE:	MAIN KITCHEN	DRAWING DETAIL							
							LOCATION:	7th. FLOOR PLAN	CAD FILE	BS-7FL-40M-KC-101-10219.DWG	DATE:	150105			
						SHEET CONTENTS:	COLD STORAGE & FLOOR CHANNEL W/ GRATING	SCALE:	1:50	DRAWN:	K	CHECKED:		APPROVED:	
								PRODUCT:	IBS-1501	SHEET NO.		DRG. NO.			

LEGEND FOR PLUMBING SERVICES

○	CWF.	Cold Water Outlet on Floor Ø12 mm. , Ø19 mm. with Valve (Soft Water)
◌	CWW.	Cold Water Outlet on Wall Ø12 mm. , Ø19 mm. with Valve (Soft Water)
●	HWF.	Hot Water Outlet on Floor Ø12 mm. , Ø19 mm. with Valve (Soft Water)
◐	HWW.	Hot Water Outlet on Wall Ø12 mm. , Ø19 mm. with Valve (Soft Water)
		Water hardness for commercial kitchens & laundries should not exceed 2.5 grains per gallon (43 ppm) Water softening treatment equipment should be installed if water analysis indicates water hardness exceeding 1.0 grains per gallon, (17 ppm) expressed as calcium carbonate.
		All Water Pressure at 40-80 psi
		Hot Water Supply Temperature at 55°C. to 60°C. and
		Soft Water Total Hardness 0-20 ppm. as CaCO ₃
⊗	WDF.	Waste Drain on Floor Ø38 mm.
⊗	WDF.	Waste Drain on Floor Ø50 mm.
⊗	CDF.	Condensed Drain on Floor Ø19 mm.
⊗	CDF.	Condensed Drain on Floor Ø38 mm.
⊗	WDW.	Waste Drain on Wall Ø38 mm.
⊗	WDW.	Waste Drain on Wall Ø50 mm.
▲	GOF.	Gas Outlet on Floor with Ball Valve (and Pressure Gauge for Each Kitchen Hight & Low Pressure)
◌	LO.	Low Pressure With Regulator (Pressure 0.5-1 psi)
◌	HI.	High Pressure (Pressure 10-20 psi)
▽	FFL.	Finish Floor Level
◌	AFF.	Above Finished Floor
⊙	SS.	Steam Supply
⊙	SR.	Steam Return

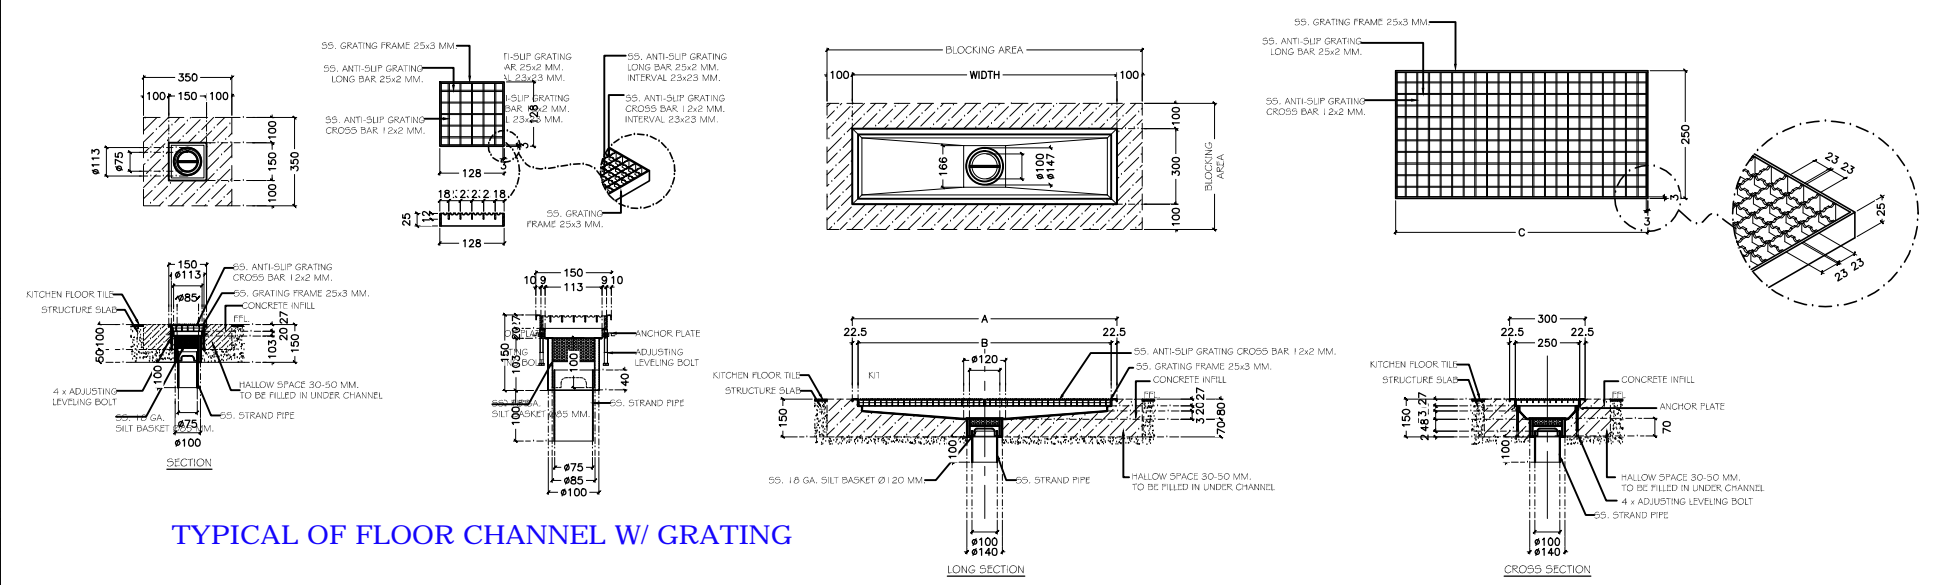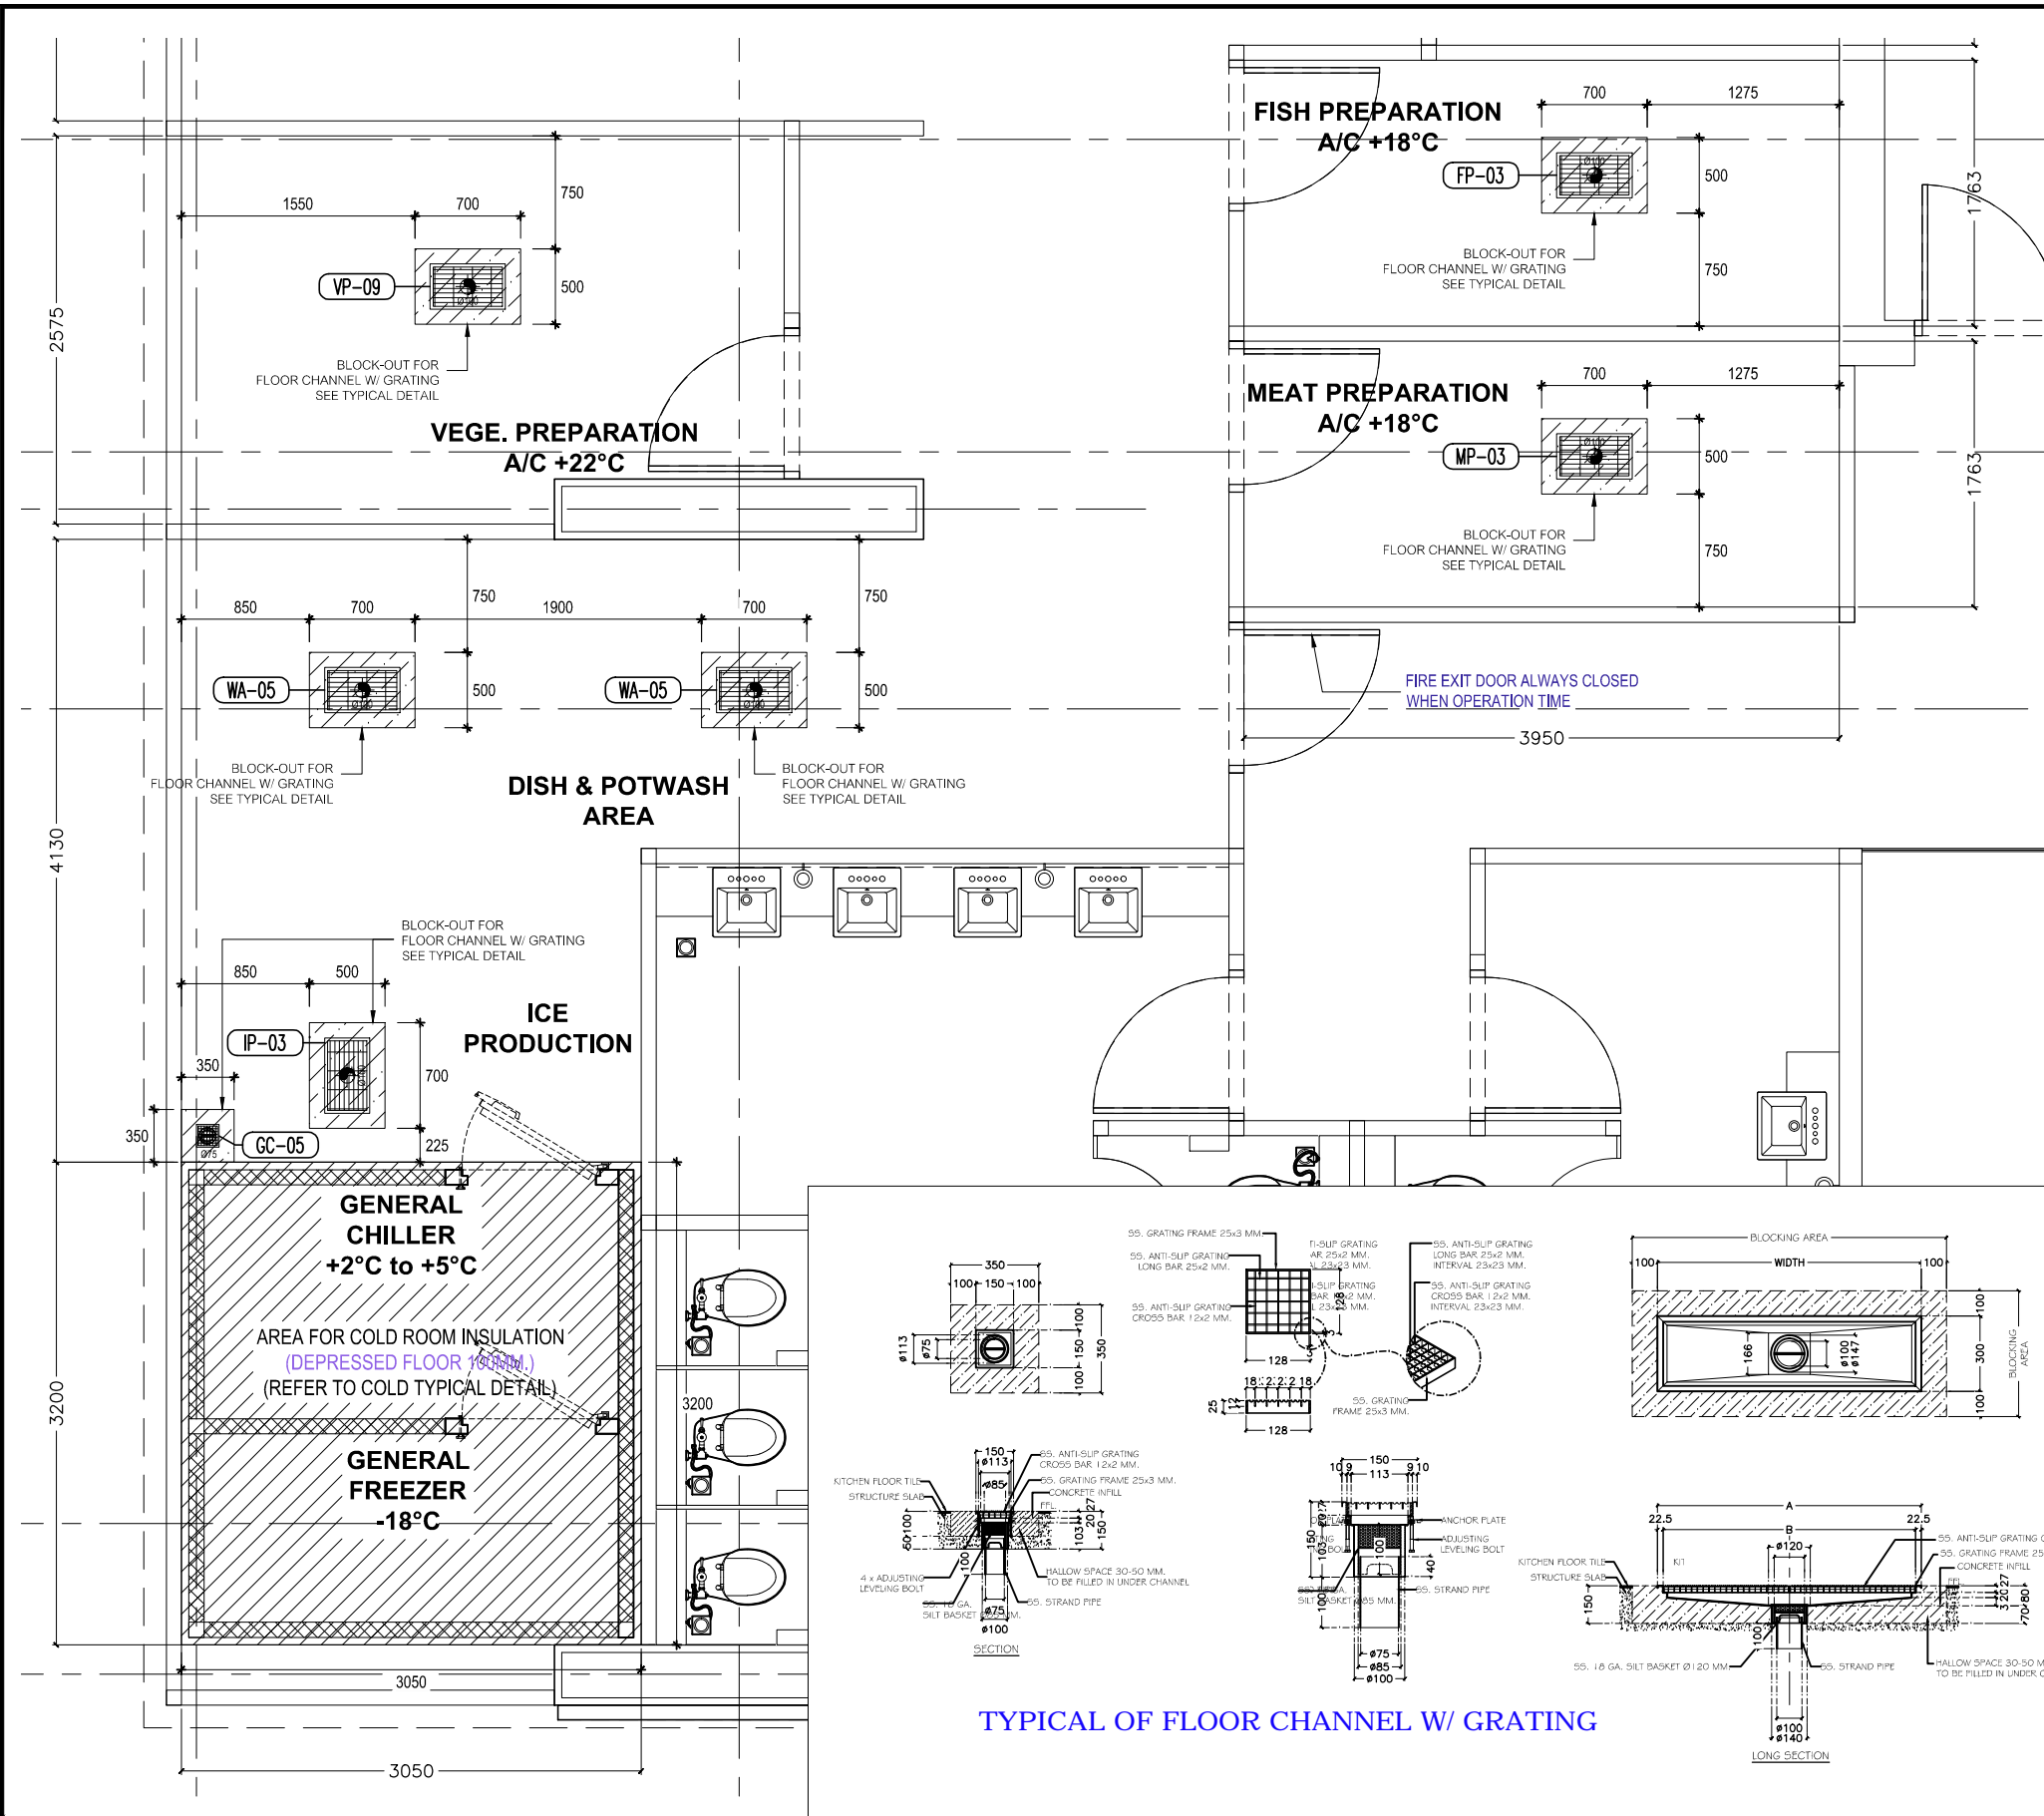

TYPICAL OF FLOOR CHANNEL W/ GRATING

UPDATE DRAWING : 160519

THANAKORN HOLDING CO., LTD.
 458/24-25 Mooban Kulapaprak
 M.1 Rattana Raj Road , T. Bangbor A. Bangbor
 Samuiprakarn 10560 , Thailand
 Tel : +662-3381465 , Fax : +662-3381849
 E-Mail : gm@thanakornholding.com

PROJECT NAME: **Ibis Styles Hotel @ Prakanong**

REV	DATE	CHK	DESCRIPTION

DRAWING TITLE:	MAIN KITCHEN
LOCATION:	7th. FLOOR PLAN
SHEET CONTENTS:	COLD STORAGE & FLOOR CHANNEL W/ GRATING

DRAWING DETAIL	
CAD FILE:	BS-TL-404-KC-101-10219.DWG
SCALE:	1:50
DATE:	150105
DESIGNER:	K
CHECKED:	
APPROVED:	
PROJECT:	IBS-1501
SHEET NO.:	
DWG. NO.:	KC-02